


**101** **FOOTING DETAIL**  
SCALE 1/2"=1'-0"

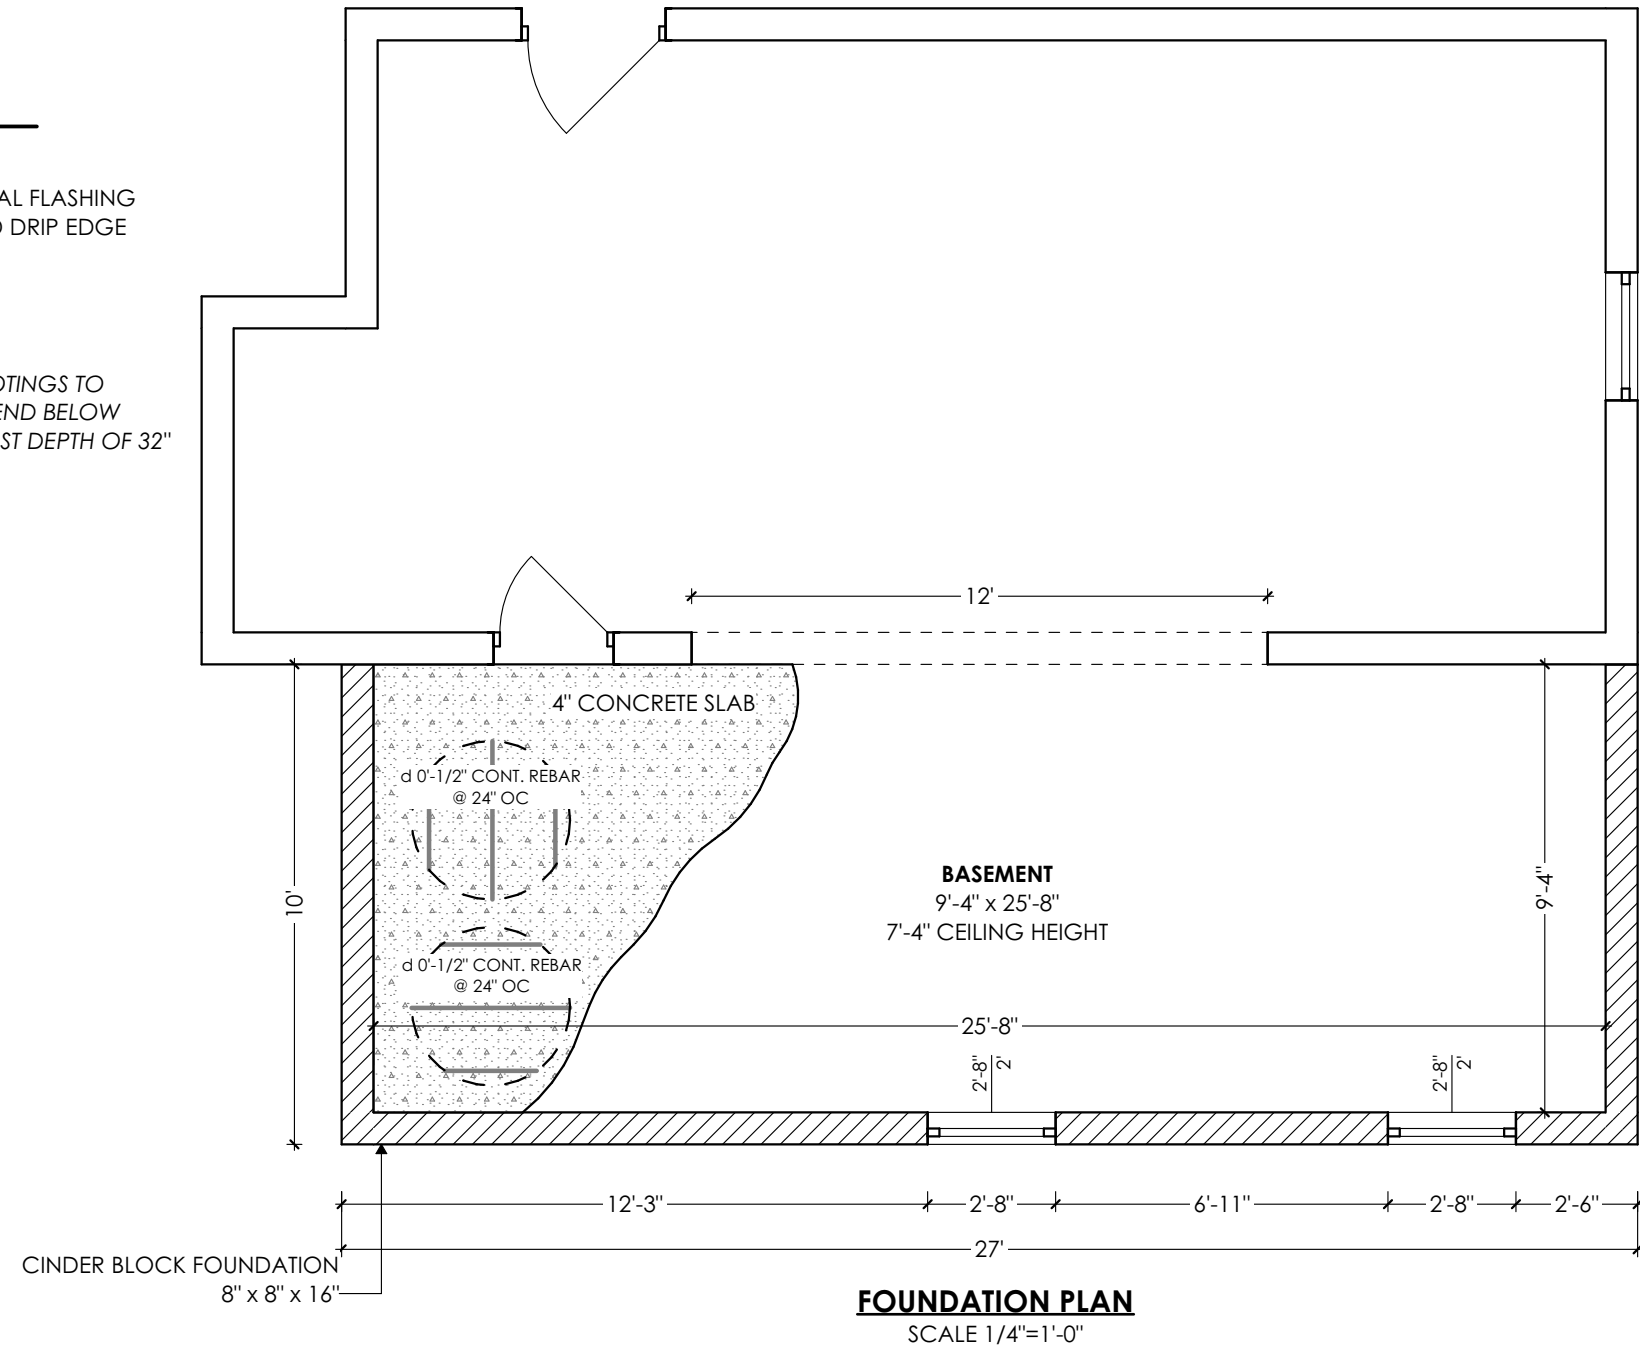

GENERAL NOTES:

00' ELEVATION

000 SQ FT

1	REVISION 1	03/15
---	------------	-------

CUSTOM PLAN

SHEET TITLE:	<b>FOUNDATION PLAN</b>
PROJECT TITLE:	<b>DECK DESIGN 87</b>
	266 S STANWOOD RD
	BEXLY, OHIO 43206

DATE:


03/15/2023

SCALE:

1/4"=1FT

SHEET:

**P-1**

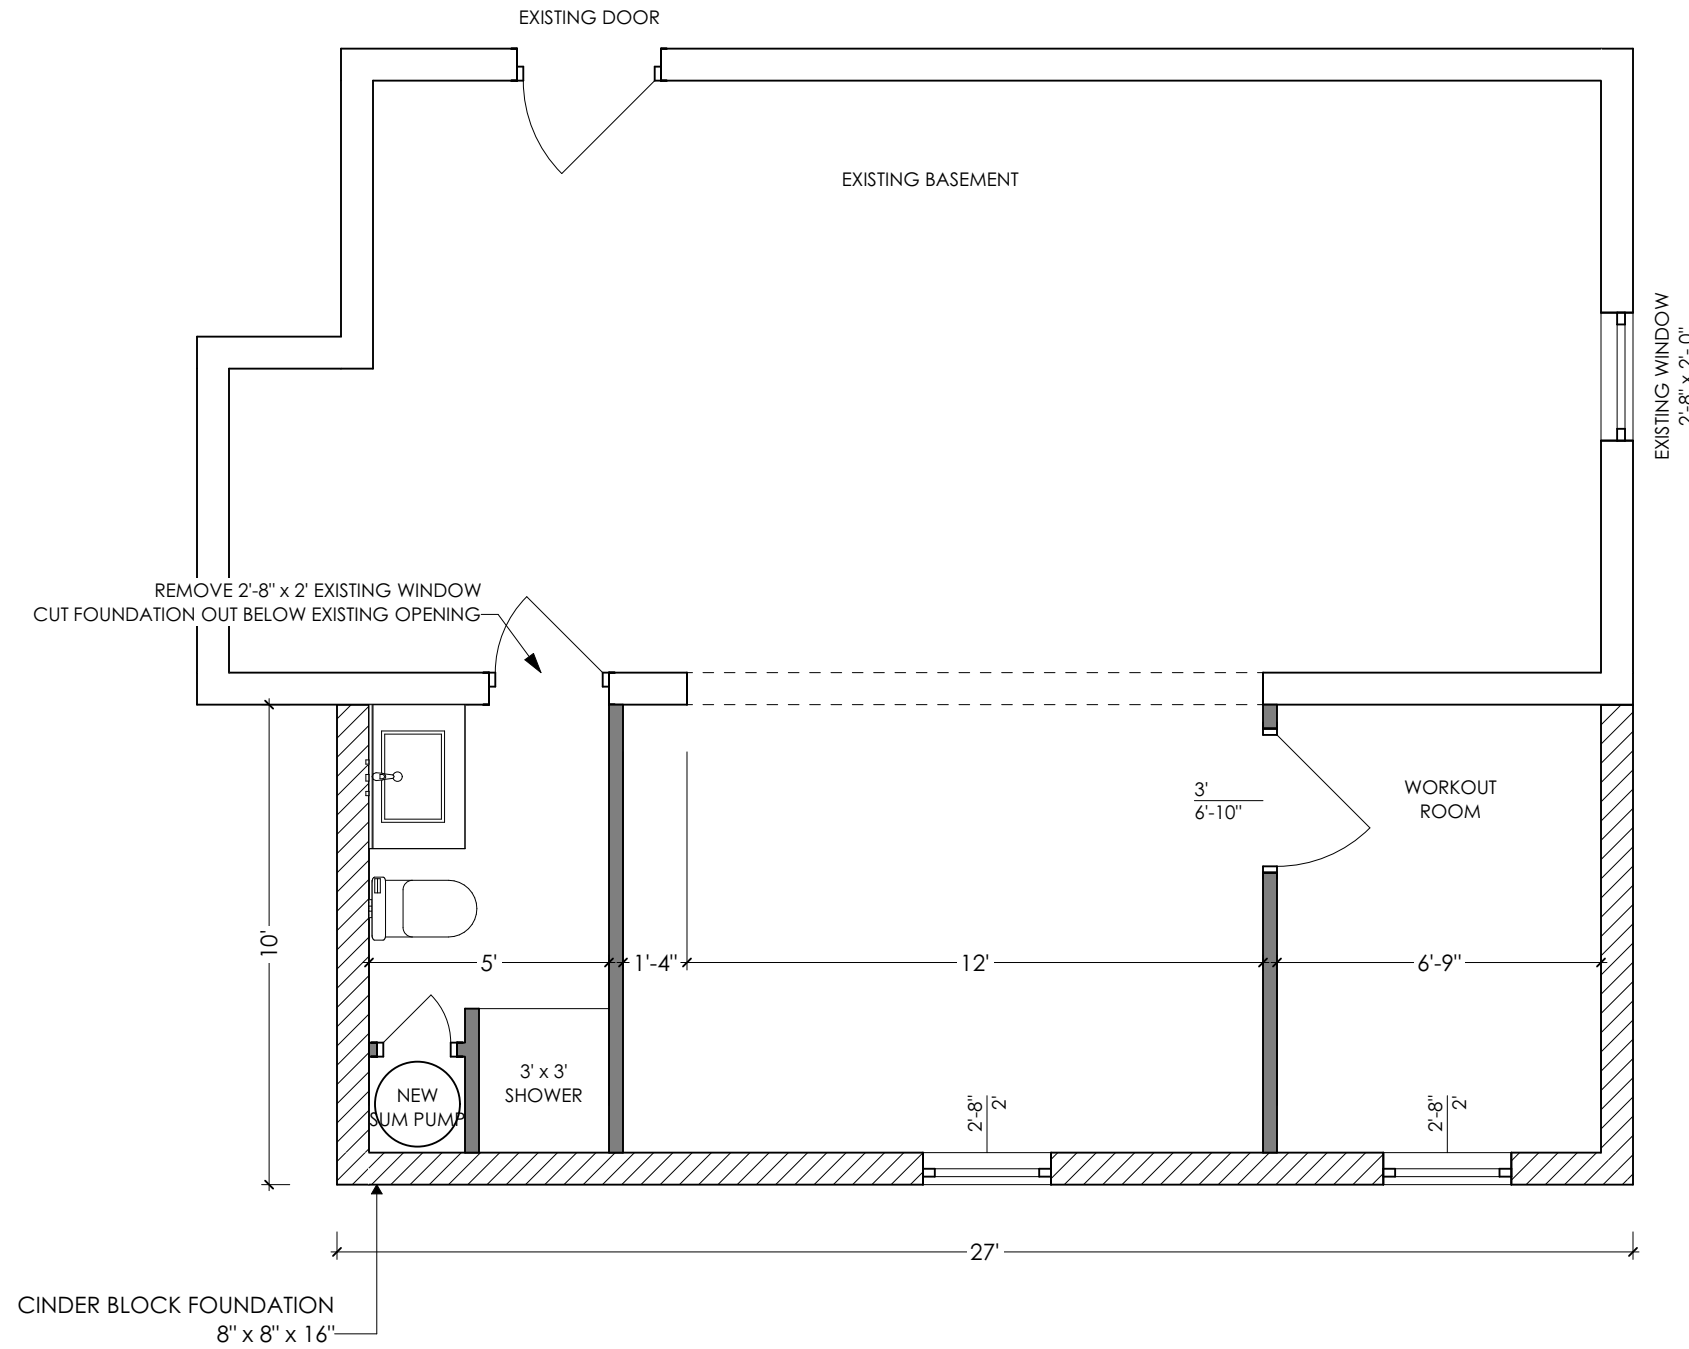

**BASEMENT LAYOUT**

SCALE 1/4"=1'-0"

GENERAL NOTES:

00" ELEVATION

000 SQ FT

1	REVISION 1	03/15
---	------------	-------

CUSTOM PLAN

SHEET TITLE:	<b>BASEMENT LAYOUT</b>
PROJECT TITLE:	<b>DECK DESIGN 87</b>
	266 S STANWOOD RD
	BEXLY, OHIO 43206

**DATE:**


03/15/2023

**SCALE:**

1/4"=1FT

**SHEET:**

**P-2**

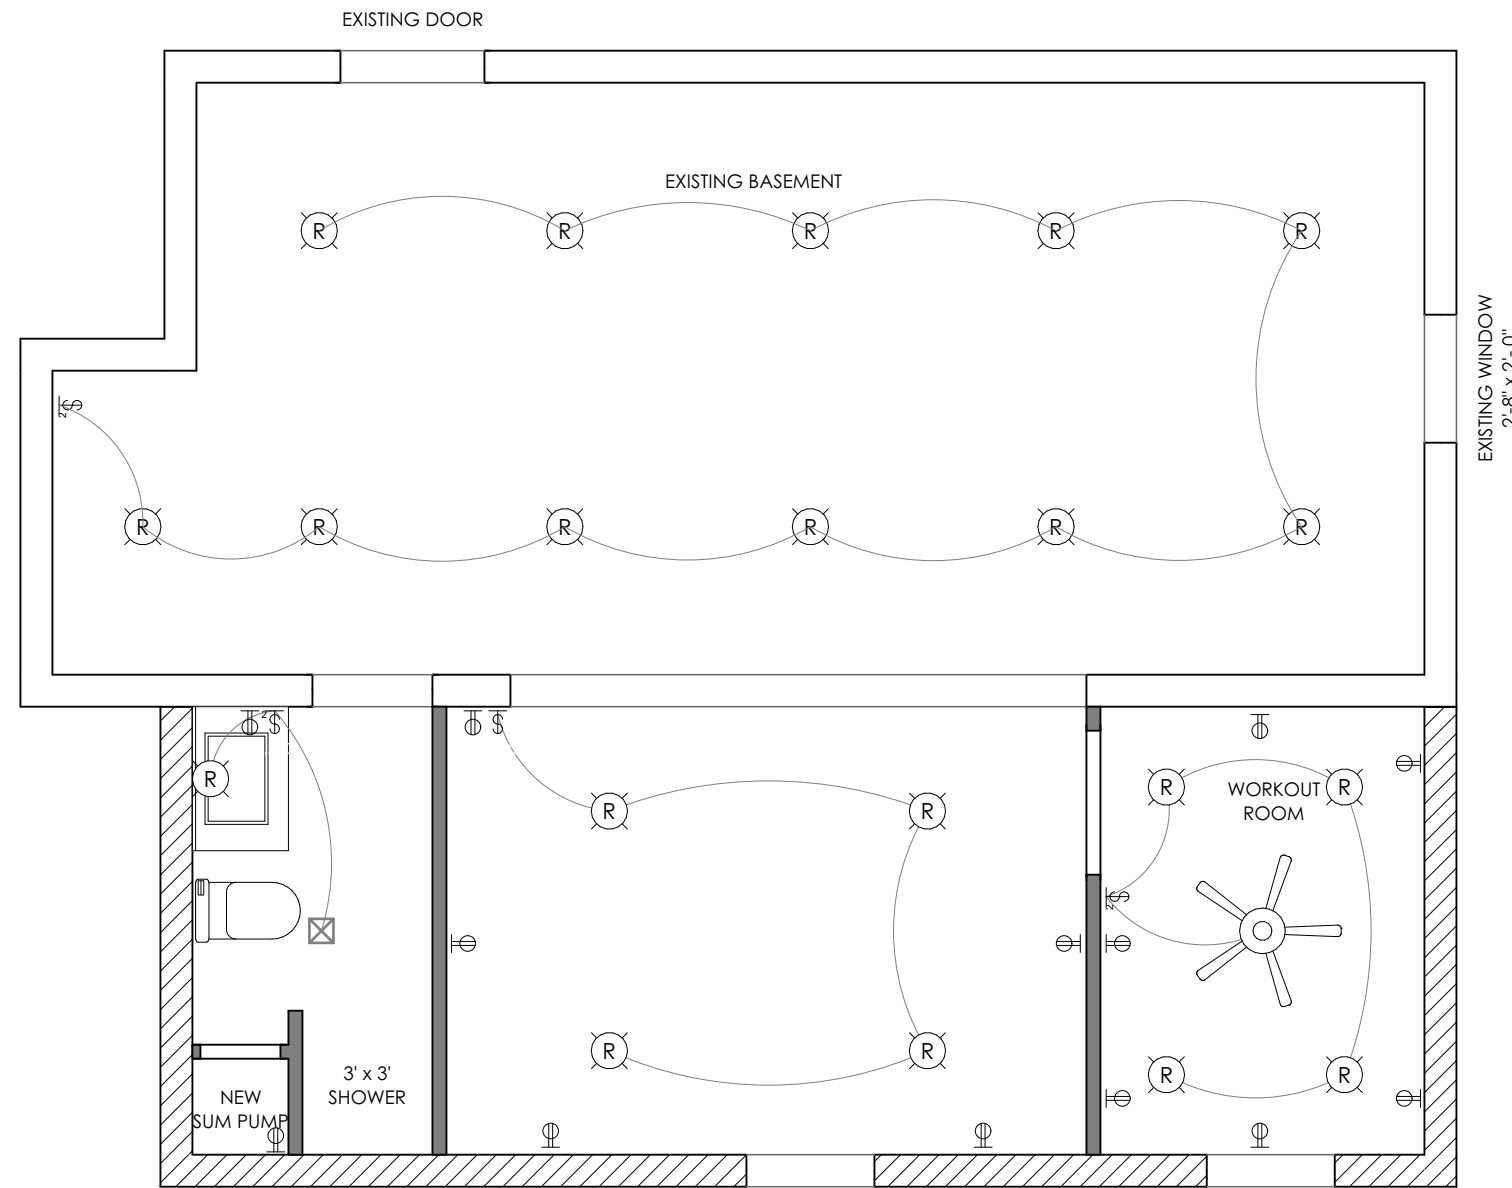

ELECTRICAL SYMBOLS LEGEND	
SYMBOL	DESCRIPTION
	CEILING FAN WITH LIGHT KIT
	RECESSED LIGHT
	110 VOLT OUTLET
	LIGTH SWITCH DOUBLE
	LIGTH SWITCH
	EXHAUST FAN

GENERAL NOTES:

00" ELEVATION

000 SQ FT

1	REVISION 1	03/15
---	------------	-------

CUSTOM PLAN

SHEET TITLE:	<b>BASEMENT ELECTRICAL LAYOUT</b>
	PROJECT TITLE:
	<b>DECK DESIGN 87</b>
	266 S STANWOOD RD BEXLY, OHIO 43206

DATE:

03/15/2023

SCALE:


1/4"=1FT

SHEET:

**P-3**

**BASEMENT ELECTRICAL LAYOUT**

SCALE 1/4"=1'-0"

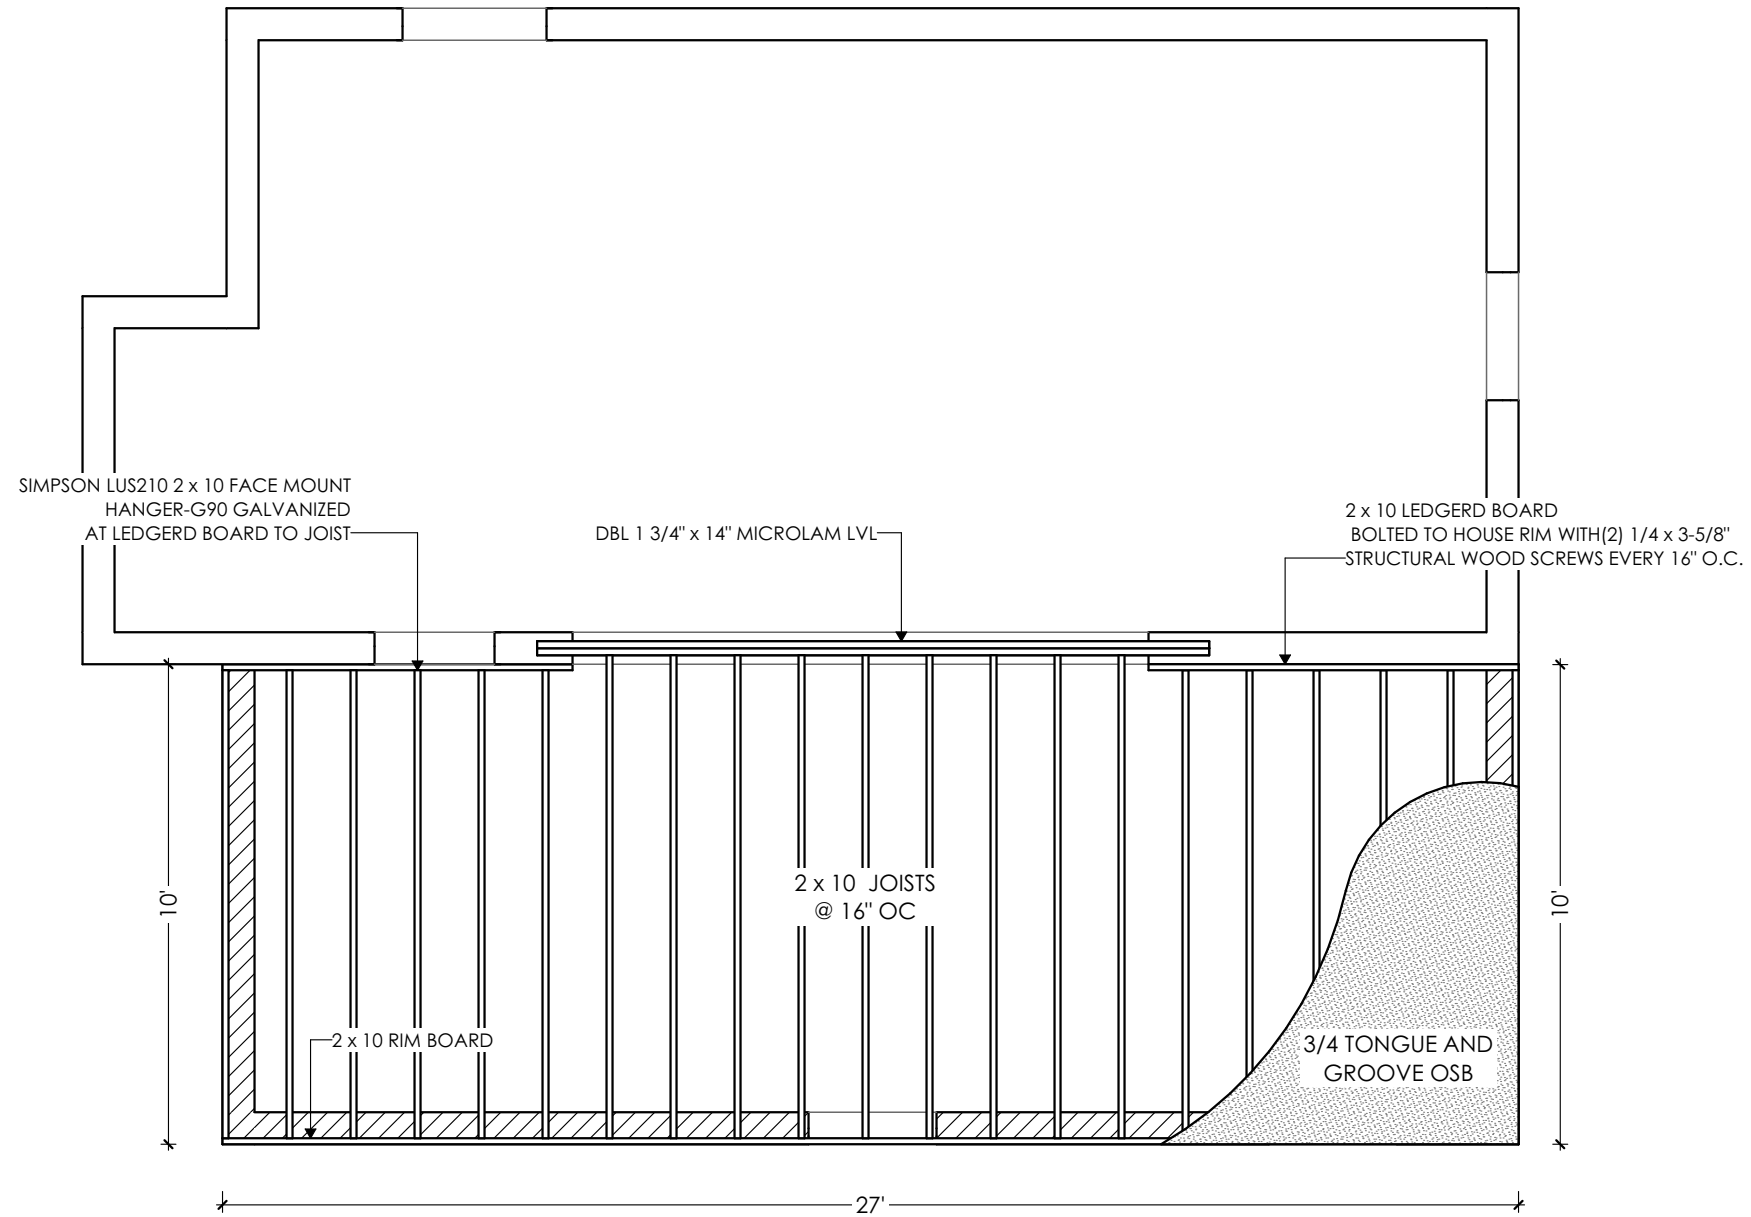

**FIRST FLOOR FRAMING**

SCALE 1/4"=1'-0"

GENERAL NOTES:

00" ELEVATION

000 SQ FT

1	REVISION 1	03/15
---	------------	-------

CUSTOM PLAN

SHEET TITLE:	<b>FIRST FLOOR FRAMING</b>
PROJECT TITLE:	<b>DECK DESIGN 87</b>
	266 S STANWOOD RD
	BEXLY, OHIO 43206

DATE:	03/15/2023
-------	------------

SCALE:	1/4"=1FT
--------	----------

SHEET:	<b>P-4</b>
--------	------------


GENERAL NOTES:

00" ELEVATION

000 SQ FT

1	REVISION 1	03/15
---	------------	-------

CUSTOM PLAN

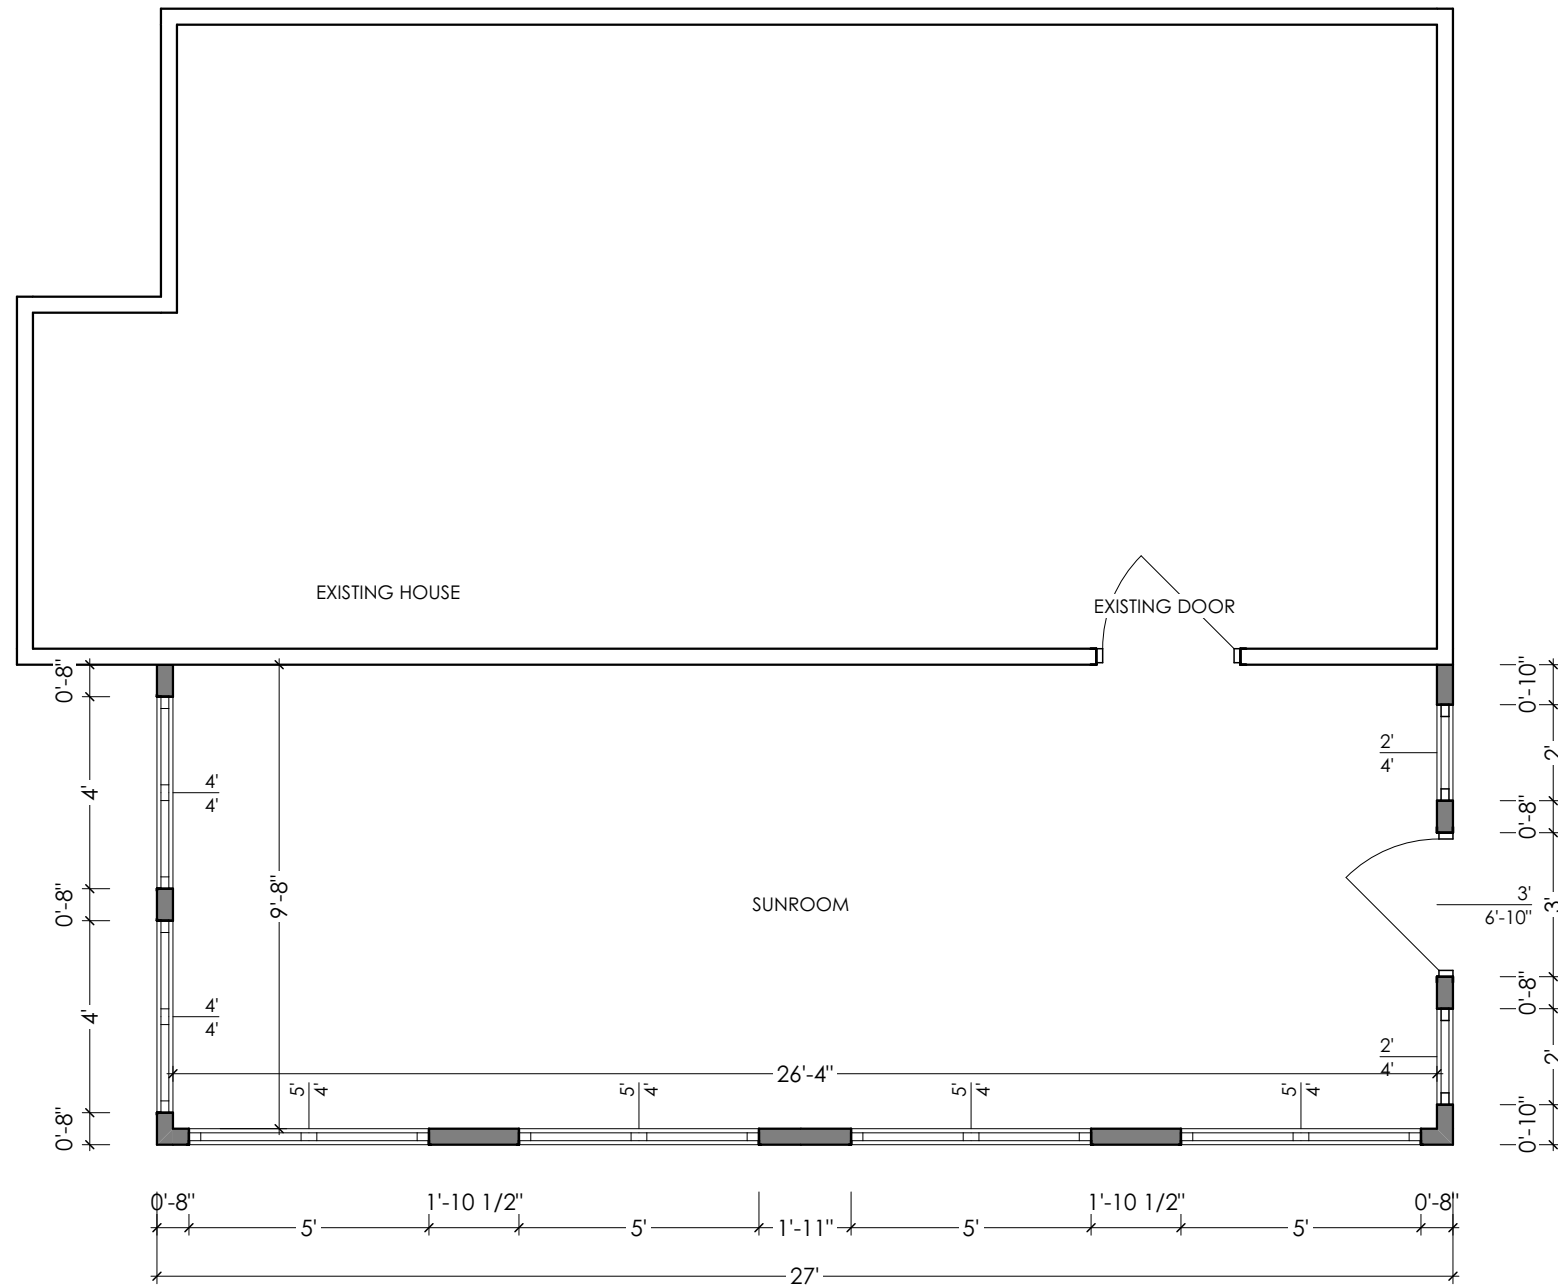

2" x 4" WALLS WITH R 15 INSULATION  
2" x 8" HEADERS FOR WINDOWS

**MAIN FLOOR PLAN**

SCALE 1/4"=1'-0"

SHEET TITLE:

**MAIN FLOOR PLAN**

PROJECT TITLE:

**DECK DESIGN 87**

266 S STANWOOD RD

BEXLY, OHIO 43206

**DATE:**


03/15/2023

**SCALE:**

1/4"=1FT

**SHEET:**

**P-5**

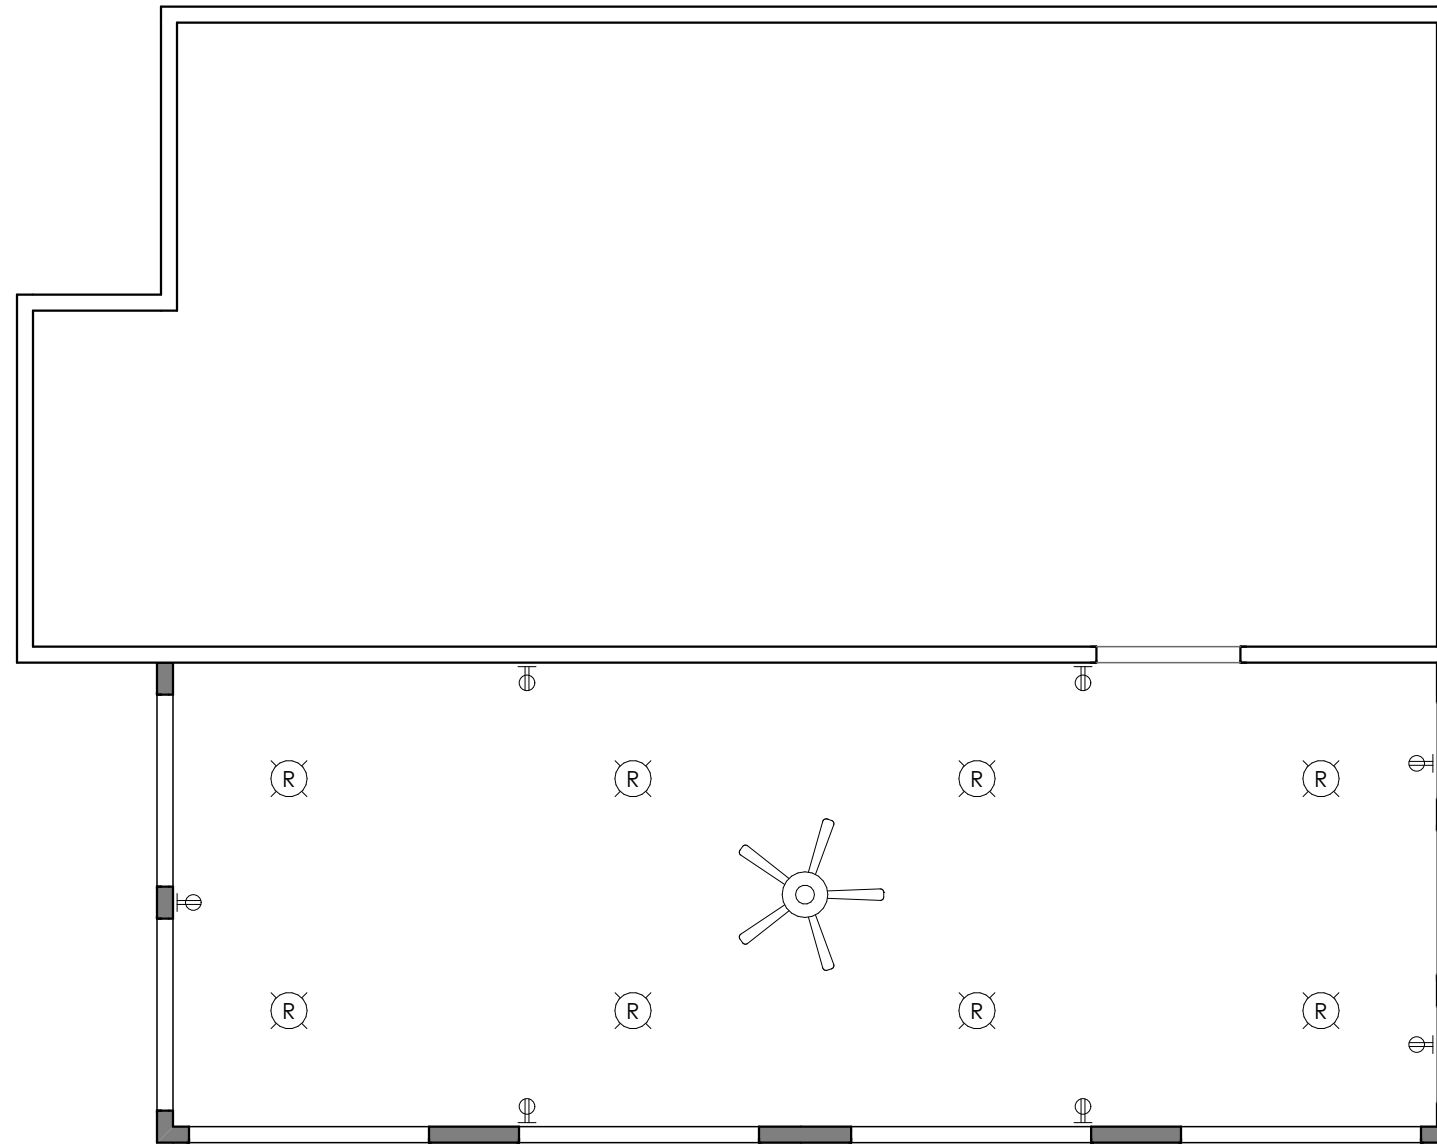

ELECTRICAL SYMBOLS LEGEND	
SYMBOL	DESCRIPTION
	CEILING FAN WITH LIGHT KIT
	RECESSED LIGHT
	110 VOLT OUTLET
	LIGHT SWITCH DOUBLE
	LIGHT SWITCH

GENERAL NOTES:

00" ELEVATION

000 SQ FT

1	REVISION 1	03/15
---	------------	-------

CUSTOM PLAN

SHEET TITLE: **MAIN ELECTRICAL LAYOUT**

PROJECT TITLE: **DECK DESIGN 87**

266 S STANWOOD RD

BEXLY, OHIO 43206

DATE:

03/15/2023


SCALE:

1/4"=1FT

SHEET:

**P-6**

**ELECTRICAL LAYOUT**  
SCALE 1/4"=1'-0"

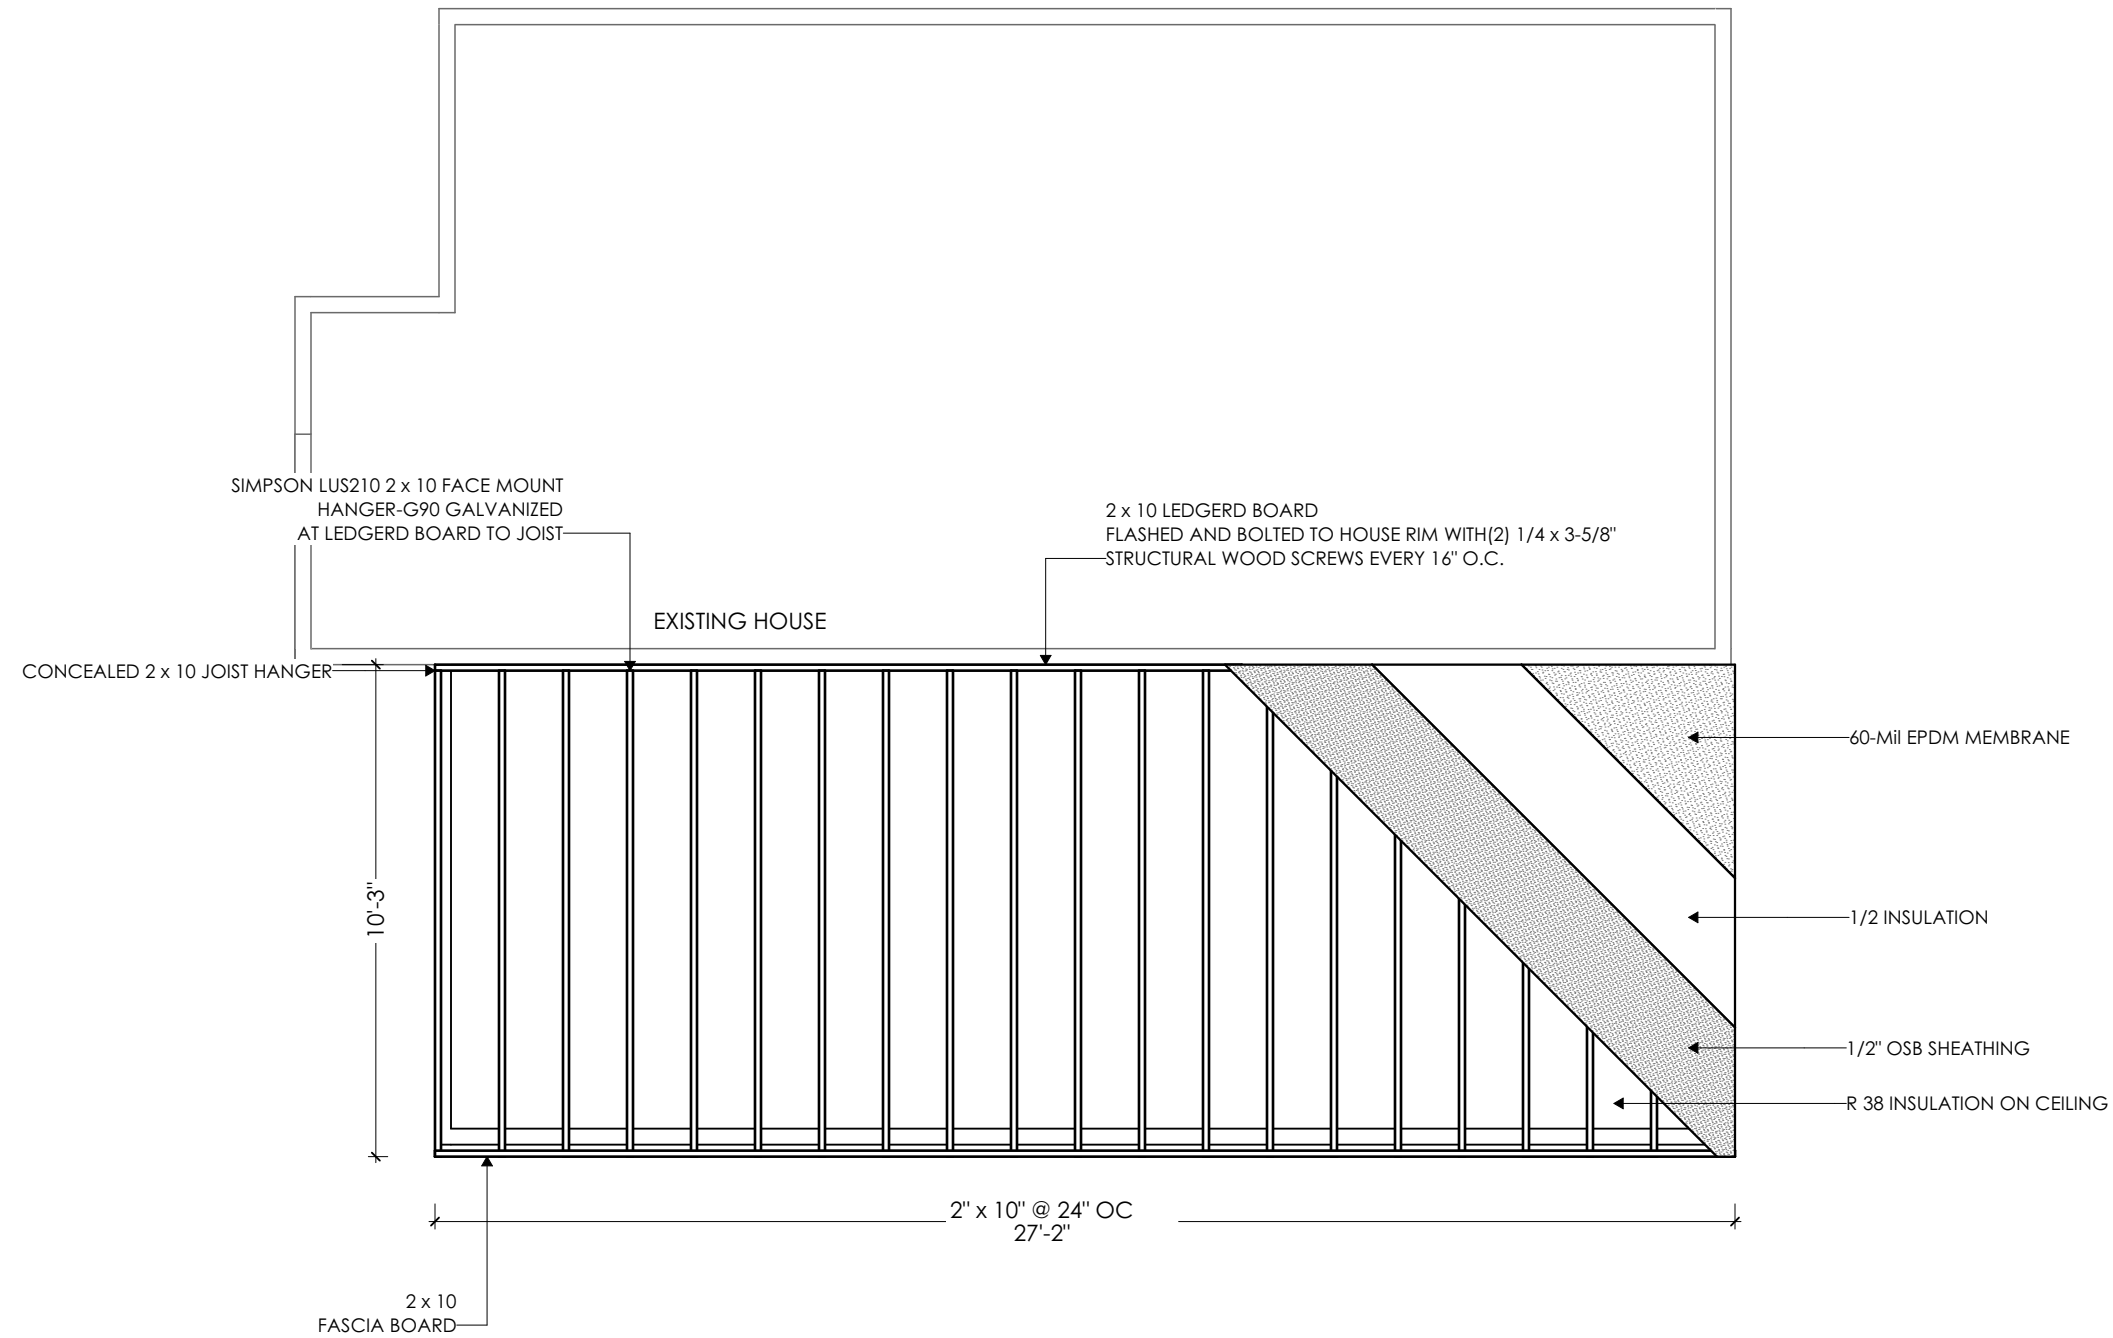

GENERAL NOTES:

00' ELEVATION

000 SQ FT

1	REVISION 1	03/15
---	------------	-------

CUSTOM PLAN

SHEET TITLE: **ROOF FRAMING PLAN**

PROJECT TITLE: **DECK DESIGN 87**

266 S STANWOOD RD

BEXLY, OHIO 43206

DATE:

03/15/2023

SCALE:

1/4"=1FT

SHEET:

**P-7**

GENERAL NOTES:

00" ELEVATION

000 SQ FT

1	REVISION 1	03/15
---	------------	-------

CUSTOM PLAN

SHEET TITLE:	<b>FRONT ELEVATION</b>
PROJECT TITLE:	<b>DECK DESIGN 87</b>
	266 S STANWOOD RD
	BEXLY, OHIO 43206

**DATE:**

03/15/2023

**SCALE:**

1/4"=1FT

**SHEET:**

**P-8**







GENERAL NOTES:

00' ELEVATION

000 SQ FT

1	REVISION 1	03/15
---	------------	-------

CUSTOM PLAN

SHEET TITLE:  
**SIDE ELEVATION**

PROJECT TITLE:  
**DECK DESIGN 87**

266 S STANWOOD RD

BEXLY, OHIO 43206

**DATE:**

03/15/2023


**SCALE:**

1/4"=1FT

**SHEET:**

**P-9**

GENERAL NOTES:

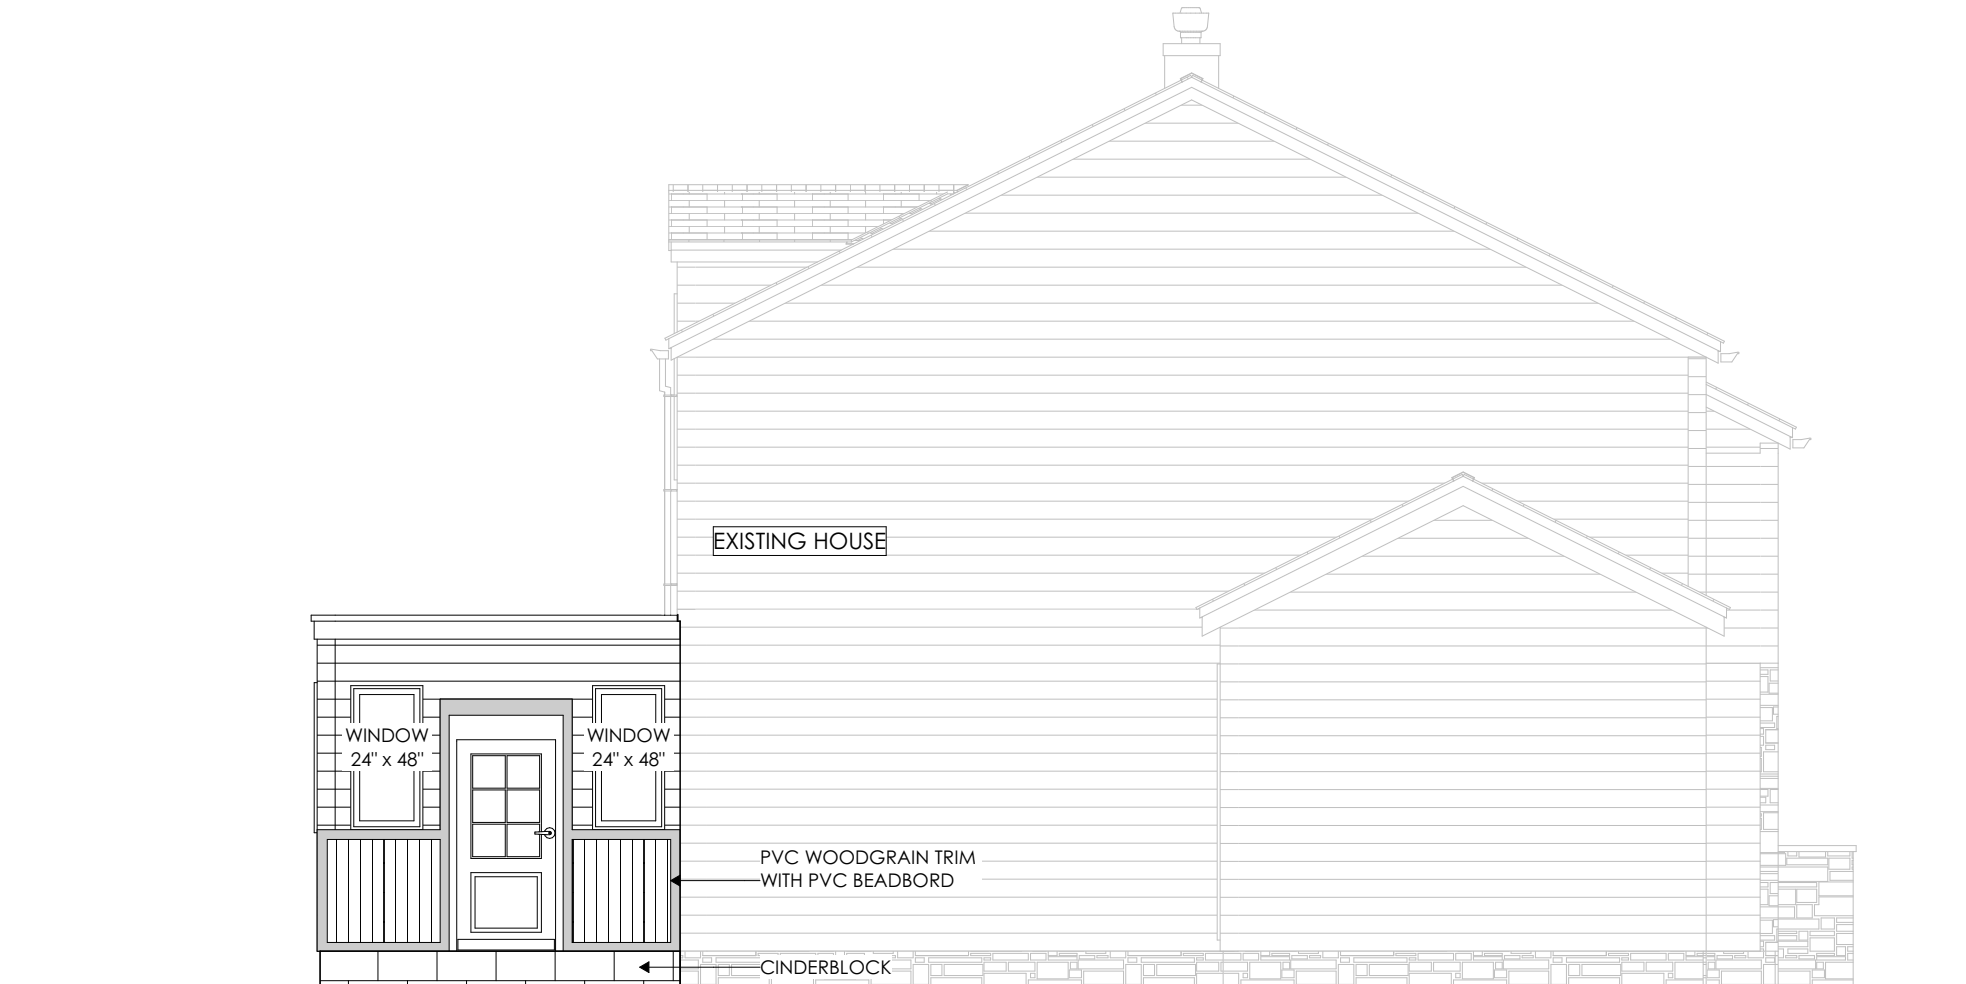

00' ELEVATION

000 SQ FT

1	REVISION 1	03/15
---	------------	-------

CUSTOM PLAN

SHEET TITLE:  
**SIDE ELEVATION**

PROJECT TITLE:  
**DECK DESIGN 87**

266 S STANWOOD RD

BEXLY, OHIO 43206

**DATE:**

03/15/2023

**SCALE:**

1/4"=1FT

**SHEET:**

**P-10**



GENERAL NOTES:

00" ELEVATION

000 SQ FT

1	REVISION 1	03/15
---	------------	-------

CUSTOM PLAN

SHEET TITLE:  
**RENDERING**

PROJECT TITLE:

**DECK DESIGN 87**

266 S STANWOOD RD

BEXLY, OHIO 43206

**DATE:**

03/15/2023

**SCALE:**

1/4"=1FT

**SHEET:**

**P-11**