


Butler electric

IAPMO
UES ER-110

FOUR SEASONS SOLAR PRODUCTS, LLC.
5005 VETERANS MEMORIAL HIGHWAY
HOLBROOK, NEW YORK 11741
DESIGNERS AND MANUFACTURERS
OF FOUR SEASONS SUNROOMS

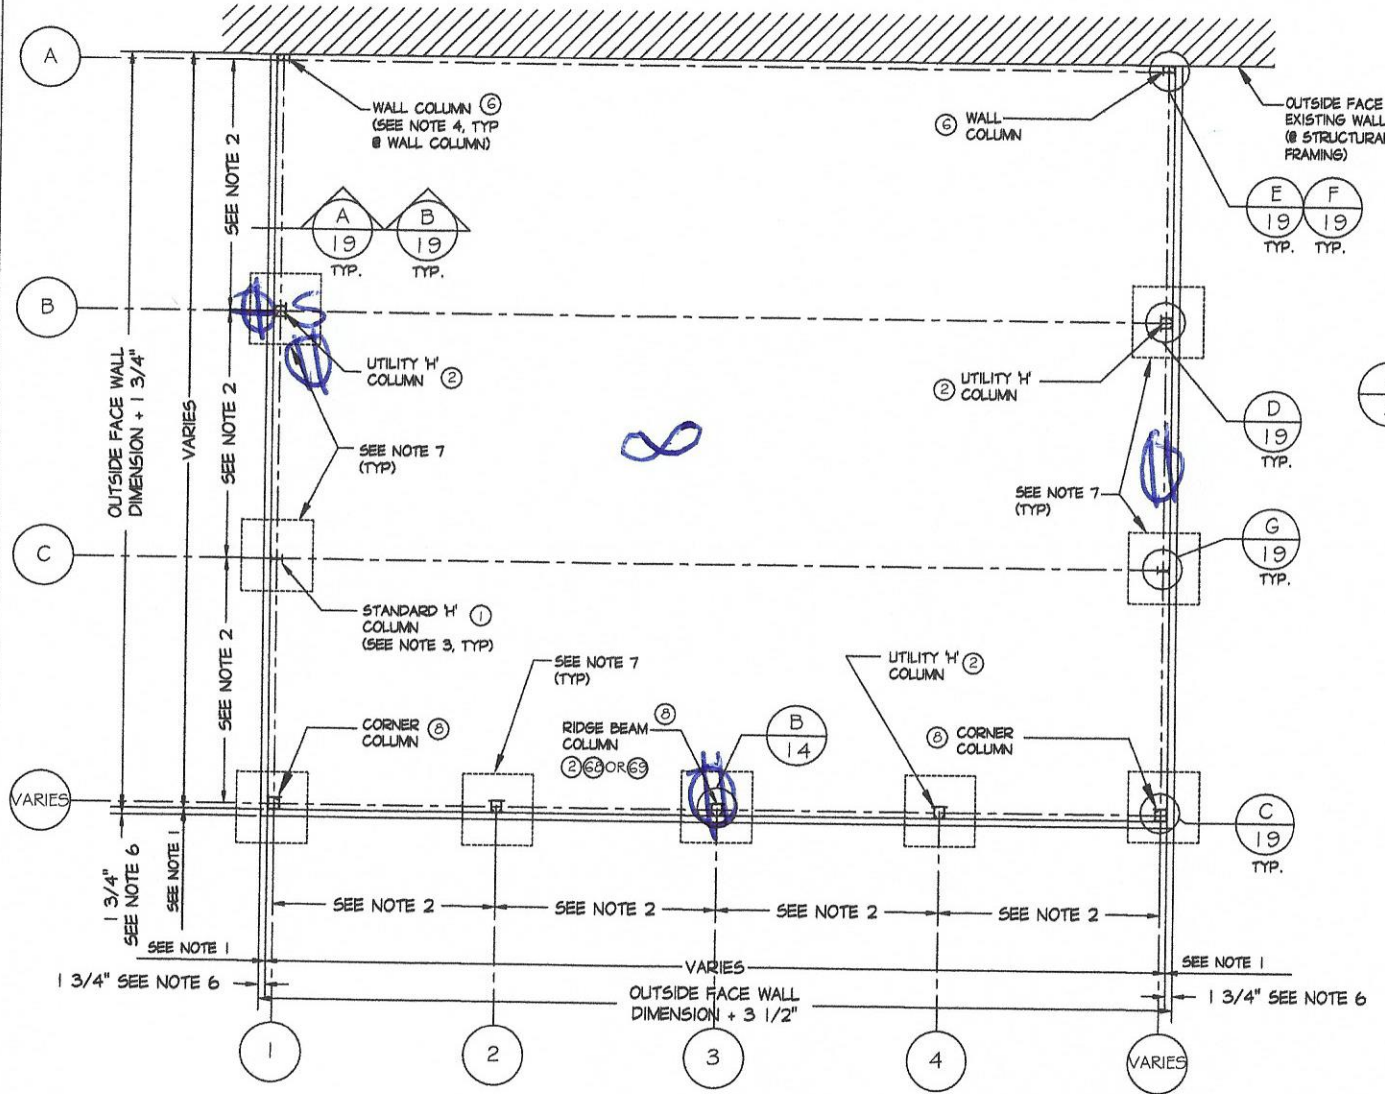

- A**
5 FLOOR PLAN SCALE=3/8"=1'-0"
- NOTE:
1. DIM. TO OUTSIDE FACE OF WALL.
 2. COLUMN SPACING VARIES DEPENDING UPON WINDOW & DOOR SIZES & CONFIGURATION. 6'-3/4" MAX. ON CENTER SPACING.
 3. ACTUAL H- CHANNEL IS SLIGHTLY LESS THAN 1 3/4" USING 1 3/4" IN CALCULATIONS OF WALL DIMENSIONS HELPS TO ACCOUNT FOR MANUFACTURING TOLERANCES IN WINDOW AND DOOR DIMENSIONS.
 4. IF H- CHANNEL IS OMITTED EXPOSED WIDTH OF CLOSED SILL IS 1 3/8" (THIS WILL NOT ALLOW FOR AN OUT OF PLUMB HOUSE WALL).
 5. MINIMUM FILL WIDTH 1 1/8" (H-CHANNEL BUTTING TO CORNER OR WINDOW/DOOR DIRECTLY INTO CORNER). IFF APPLICABLE.
 6. MINIMUM FOUNDATION PROJECTION REQ'D TO ACHIEVE DESIRED ANCHOR BOLT CAPACITY (FOR CONCRETE FOUNDATION ONLY).
 7. FOR FOOTING SIZE & WIDTH REQUIRED, SEE GENERAL-16 THRU GENERAL-19 DRAWINGS.
 8. FOOTING TYPE MAY VARY, COORDINATE FOOTING TYPE WITH DETAILS & CHARTS.

DRAWING TITLE
FOUNDATION PLAN
SUN & SHADE CATHEDRAL

REV. No.	DATE	BY
1	10-10-17	RD
2	10-10-17	RD
3	10-10-17	RD
4	10-10-17	RD
5	10-10-17	RD

REVIEWED BY: AS
DWG. BY: RD
DATE: 1-10-11
JOB#: SHADECATH-05

Electrical Plan
All work per 2017 MEC