


101 **FOOTING DETAIL**
SCALE 1/2"=1'-0"

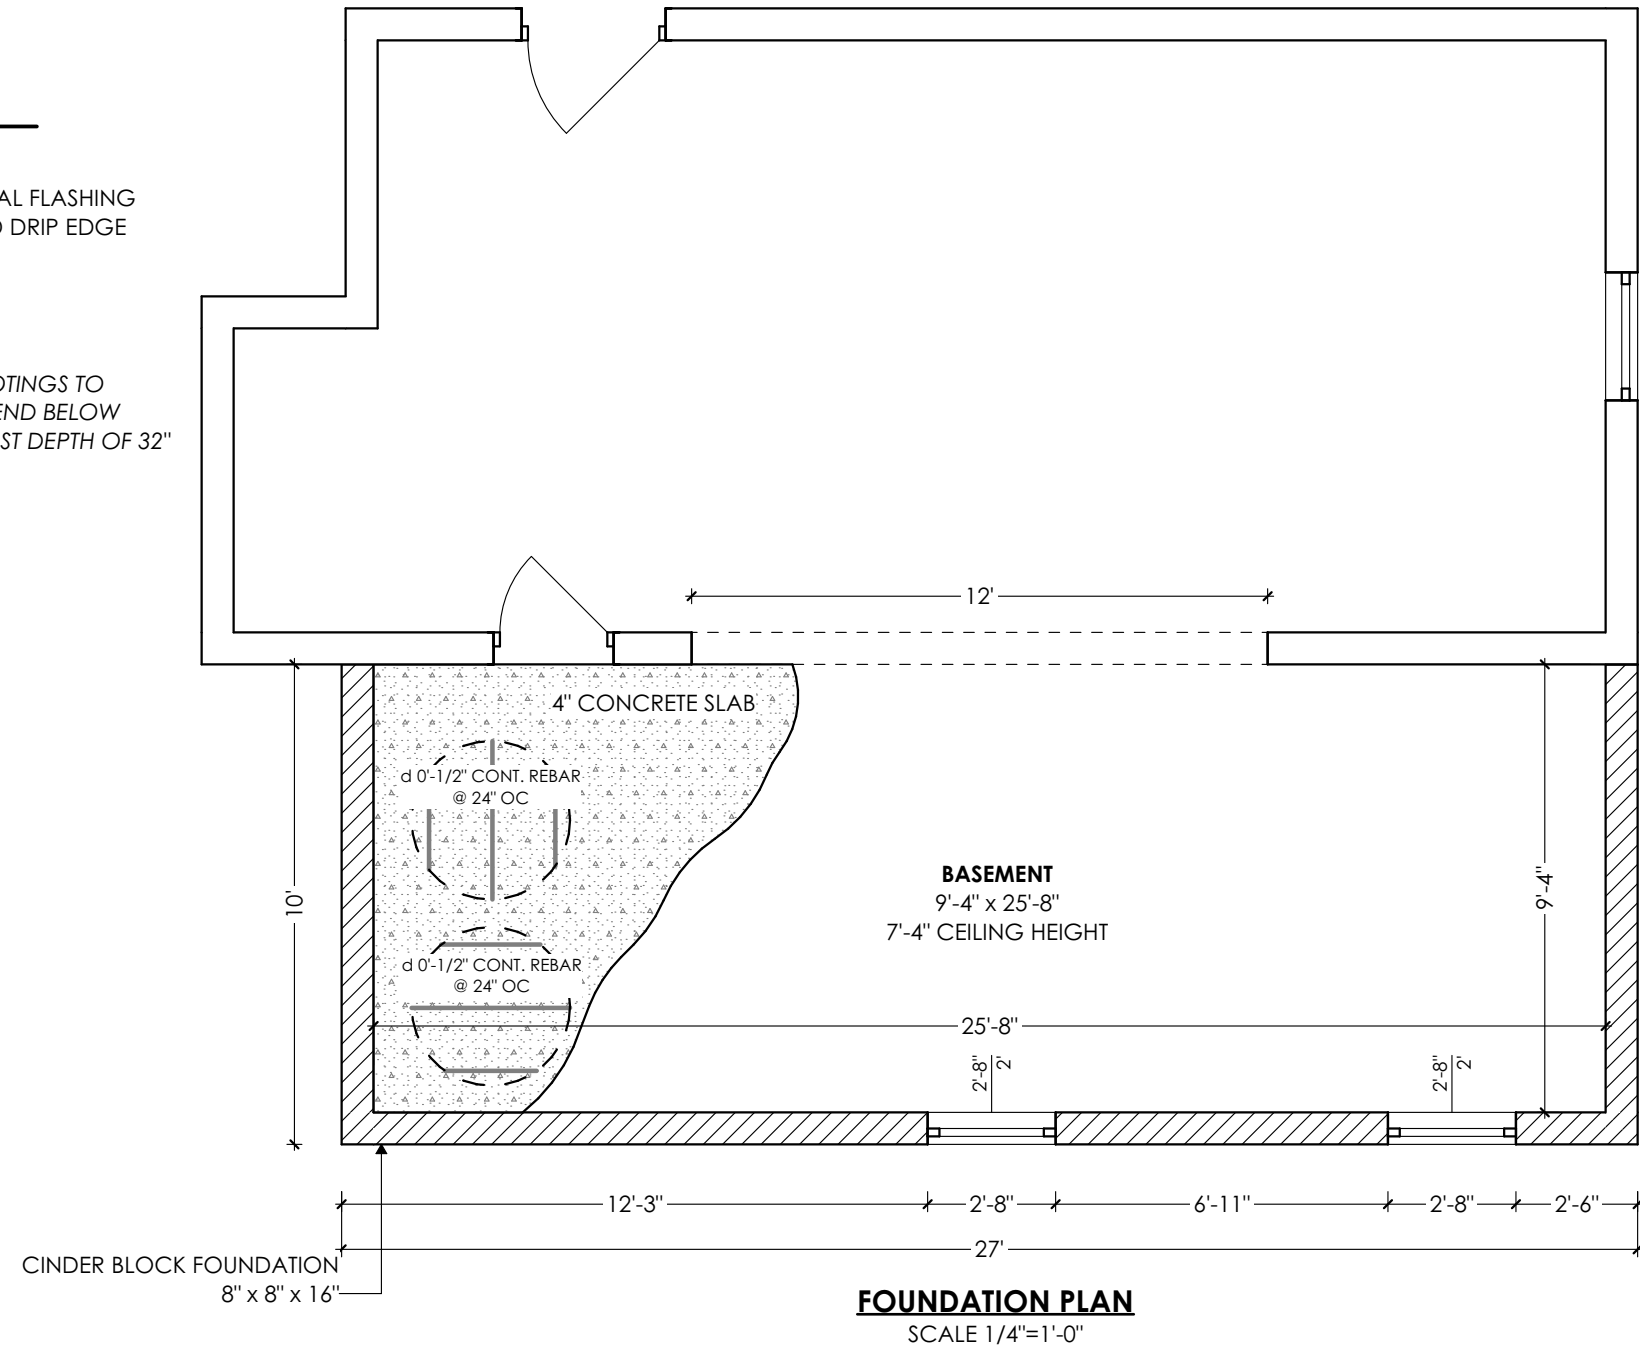

GENERAL NOTES:

00" ELEVATION

000 SQ FT

1	REVISION 1	03/15
---	------------	-------

CUSTOM PLAN

SHEET TITLE:	FOUNDATION PLAN
PROJECT TITLE:	DECK DESIGN 87
	266 S STANWOOD RD
	BEXLY, OHIO 43206

DATE:


03/15/2023

SCALE:

1/4"=1FT

SHEET:

P-1

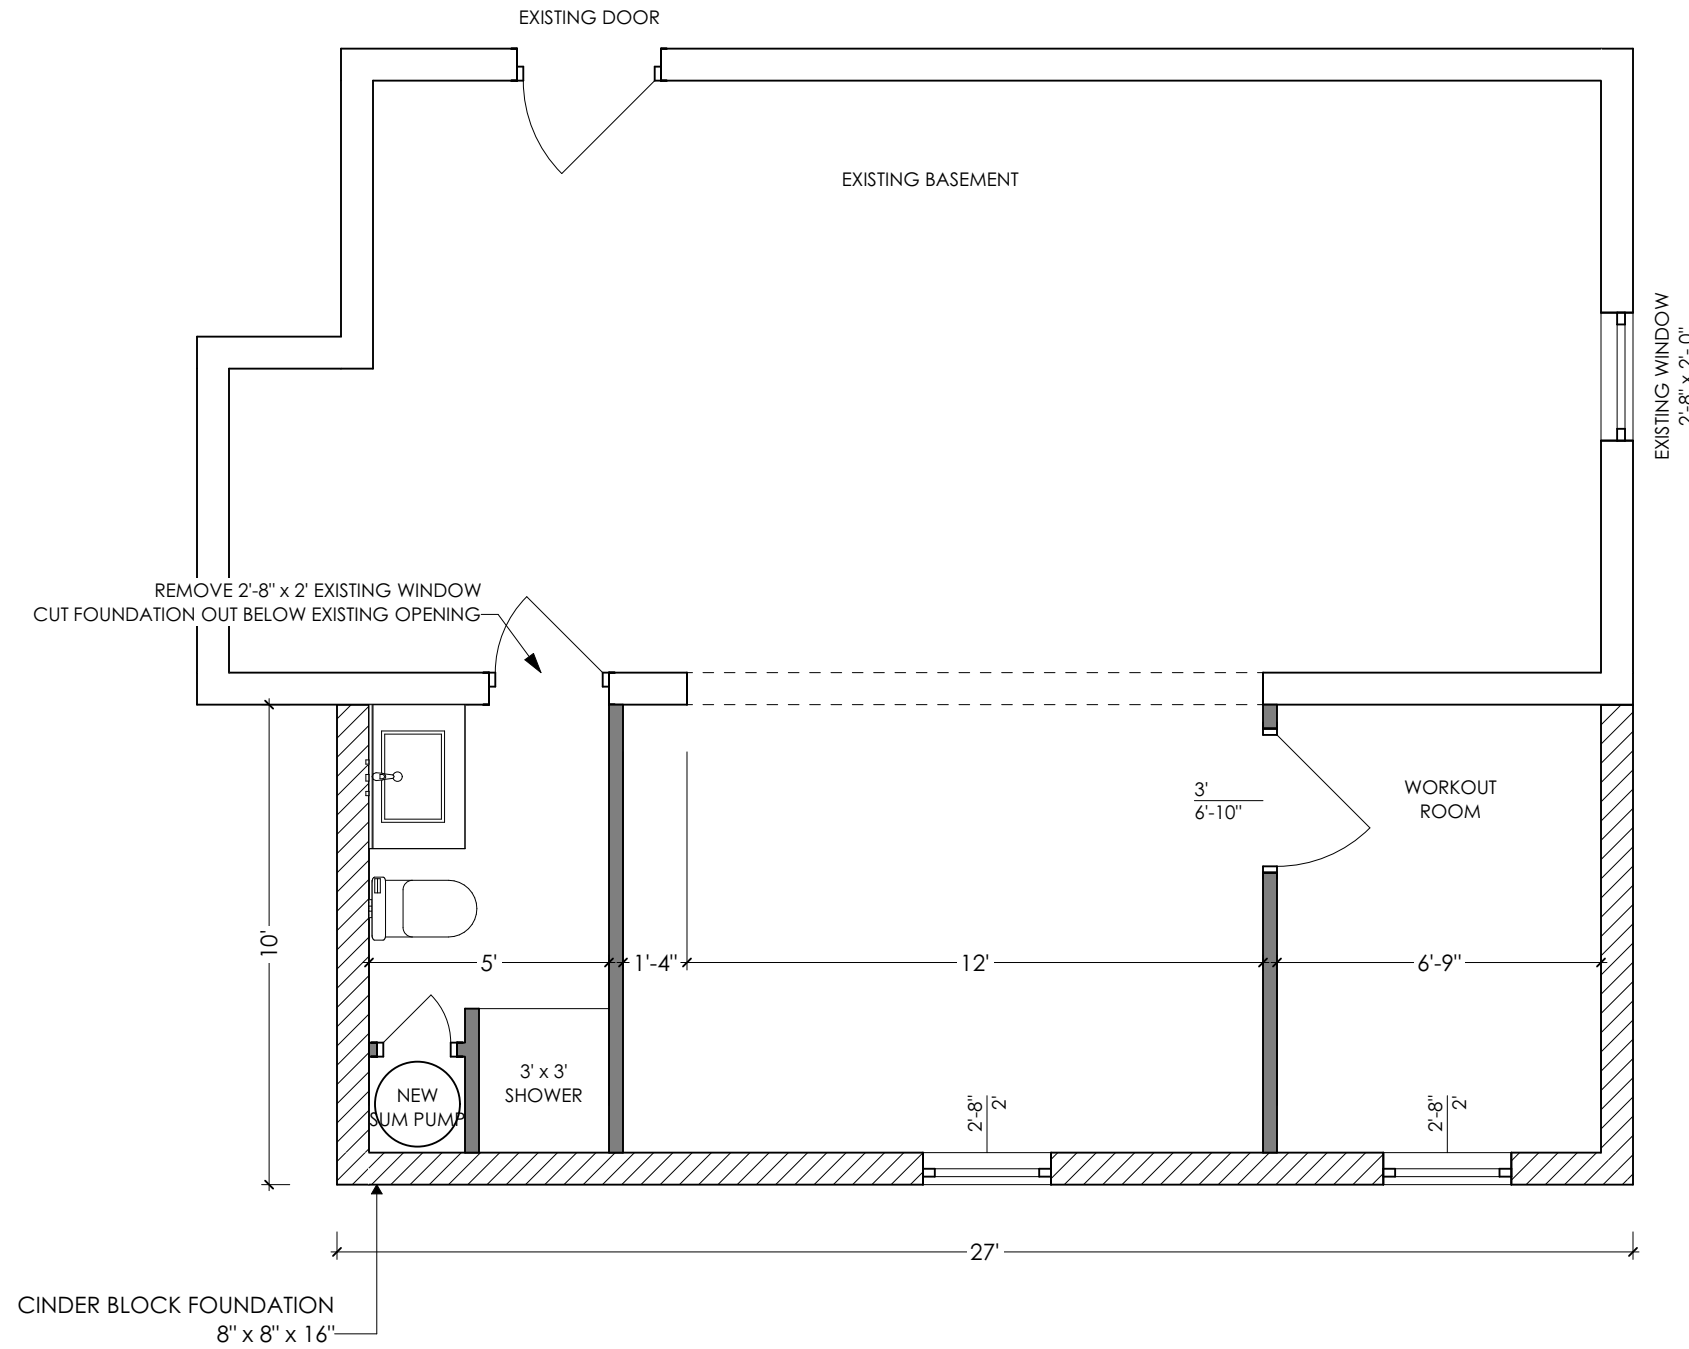

BASEMENT LAYOUT

SCALE 1/4"=1'-0"

GENERAL NOTES:

00" ELEVATION

000 SQ FT

1	REVISION 1	03/15
---	------------	-------

CUSTOM PLAN

SHEET TITLE:	BASEMENT LAYOUT
PROJECT TITLE:	DECK DESIGN 87
	266 S STANWOOD RD
	BEXLY, OHIO 43206

DATE:


03/15/2023

SCALE:

1/4"=1FT

SHEET:

P-2

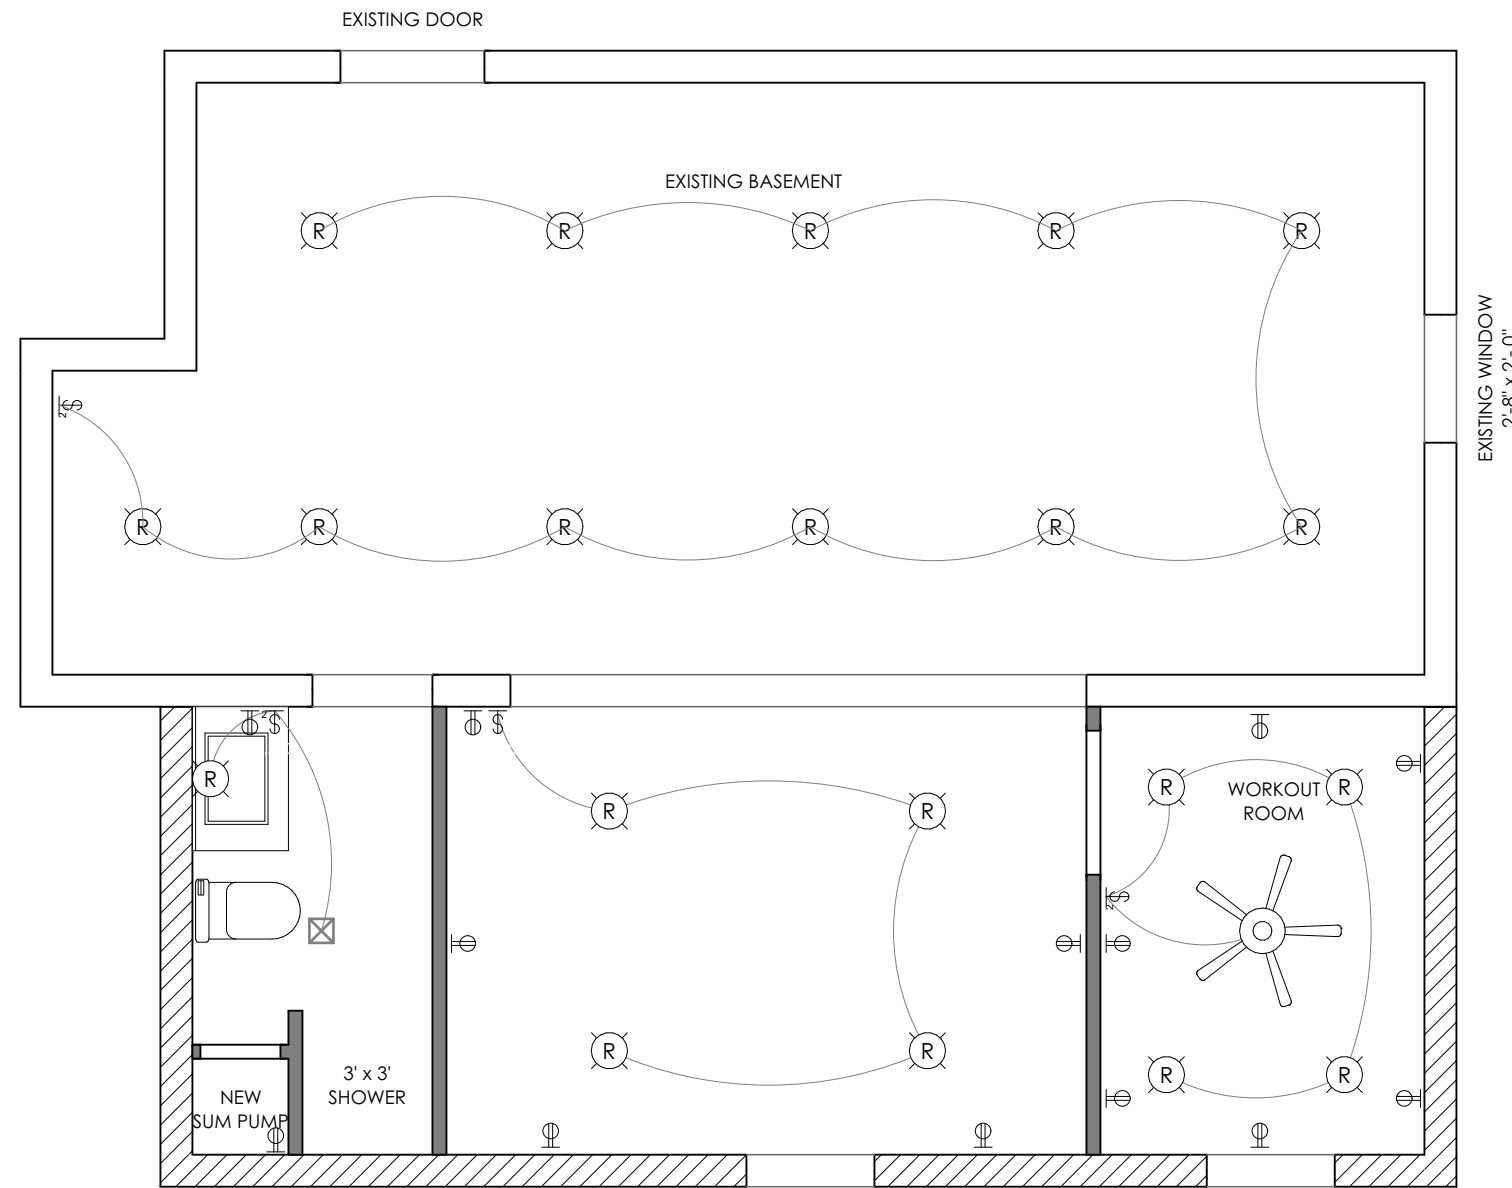

ELECTRICAL SYMBOLS LEGEND	
SYMBOL	DESCRIPTION
	CEILING FAN WITH LIGHT KIT
	RECESSED LIGHT
	110 VOLT OUTLET
	LIGTH SWITCH DOUBLE
	LIGTH SWITCH
	EXHAUST FAN

GENERAL NOTES:

00" ELEVATION

000 SQ FT

1	REVISION 1	03/15
---	------------	-------

CUSTOM PLAN


SHEET TITLE:	BASEMENT ELECTRICAL LAYOUT
	PROJECT TITLE:
	DECK DESIGN 87
	266 S STANWOOD RD BEXLY, OHIO 43206

DATE:
03/15/2023

SCALE:
1/4"=1FT

SHEET:

BASEMENT ELECTRICAL LAYOUT
SCALE 1/4"=1'-0"

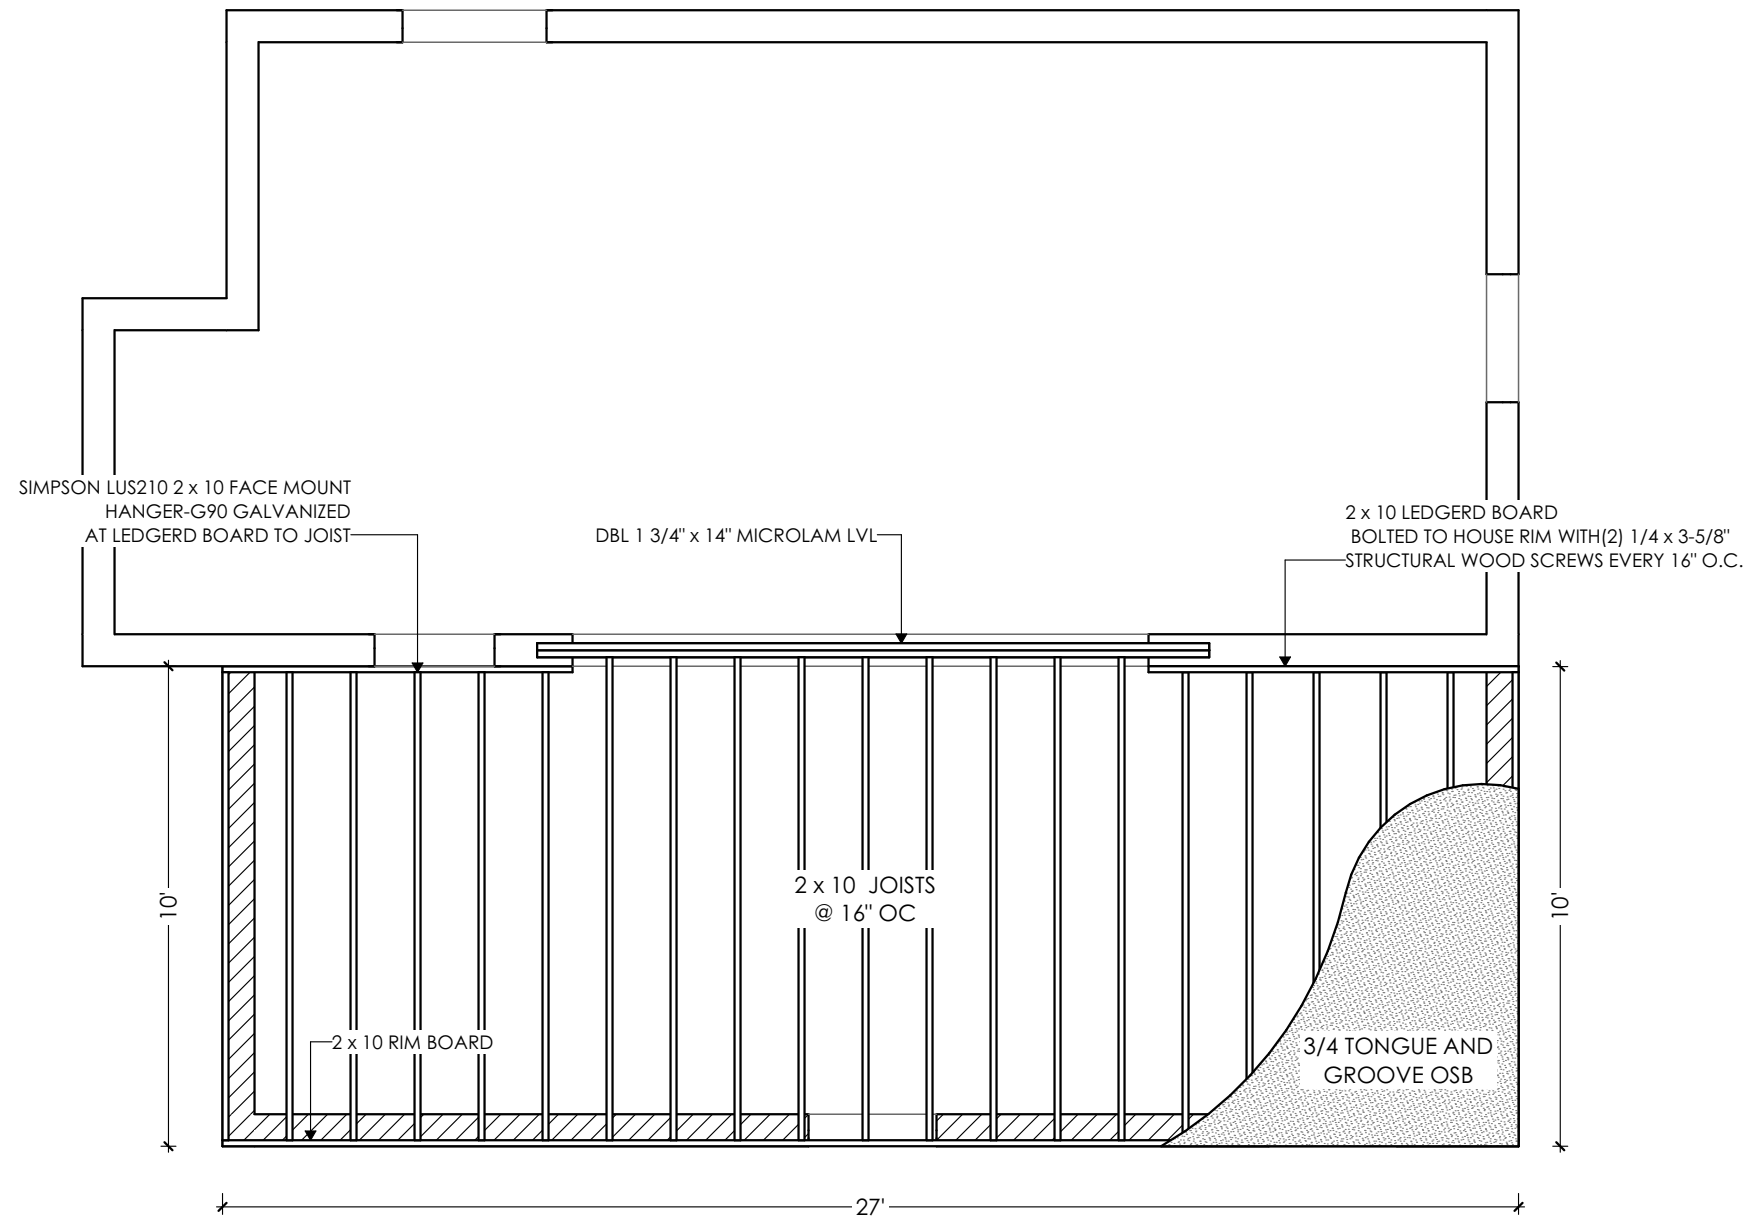

FIRST FLOOR FRAMING

SCALE 1/4"=1'-0"

GENERAL NOTES:

00" ELEVATION

000 SQ FT

1	REVISION 1	03/15
---	------------	-------

CUSTOM PLAN

SHEET TITLE:	FIRST FLOOR FRAMING
PROJECT TITLE:	DECK DESIGN 87
	266 S STANWOOD RD
	BEXLY, OHIO 43206

DATE:	03/15/2023
-------	------------

SCALE:	1/4"=1FT
--------	----------

SHEET:	P-4
--------	------------


GENERAL NOTES:

00" ELEVATION

000 SQ FT

1	REVISION 1	03/15
---	------------	-------

CUSTOM PLAN

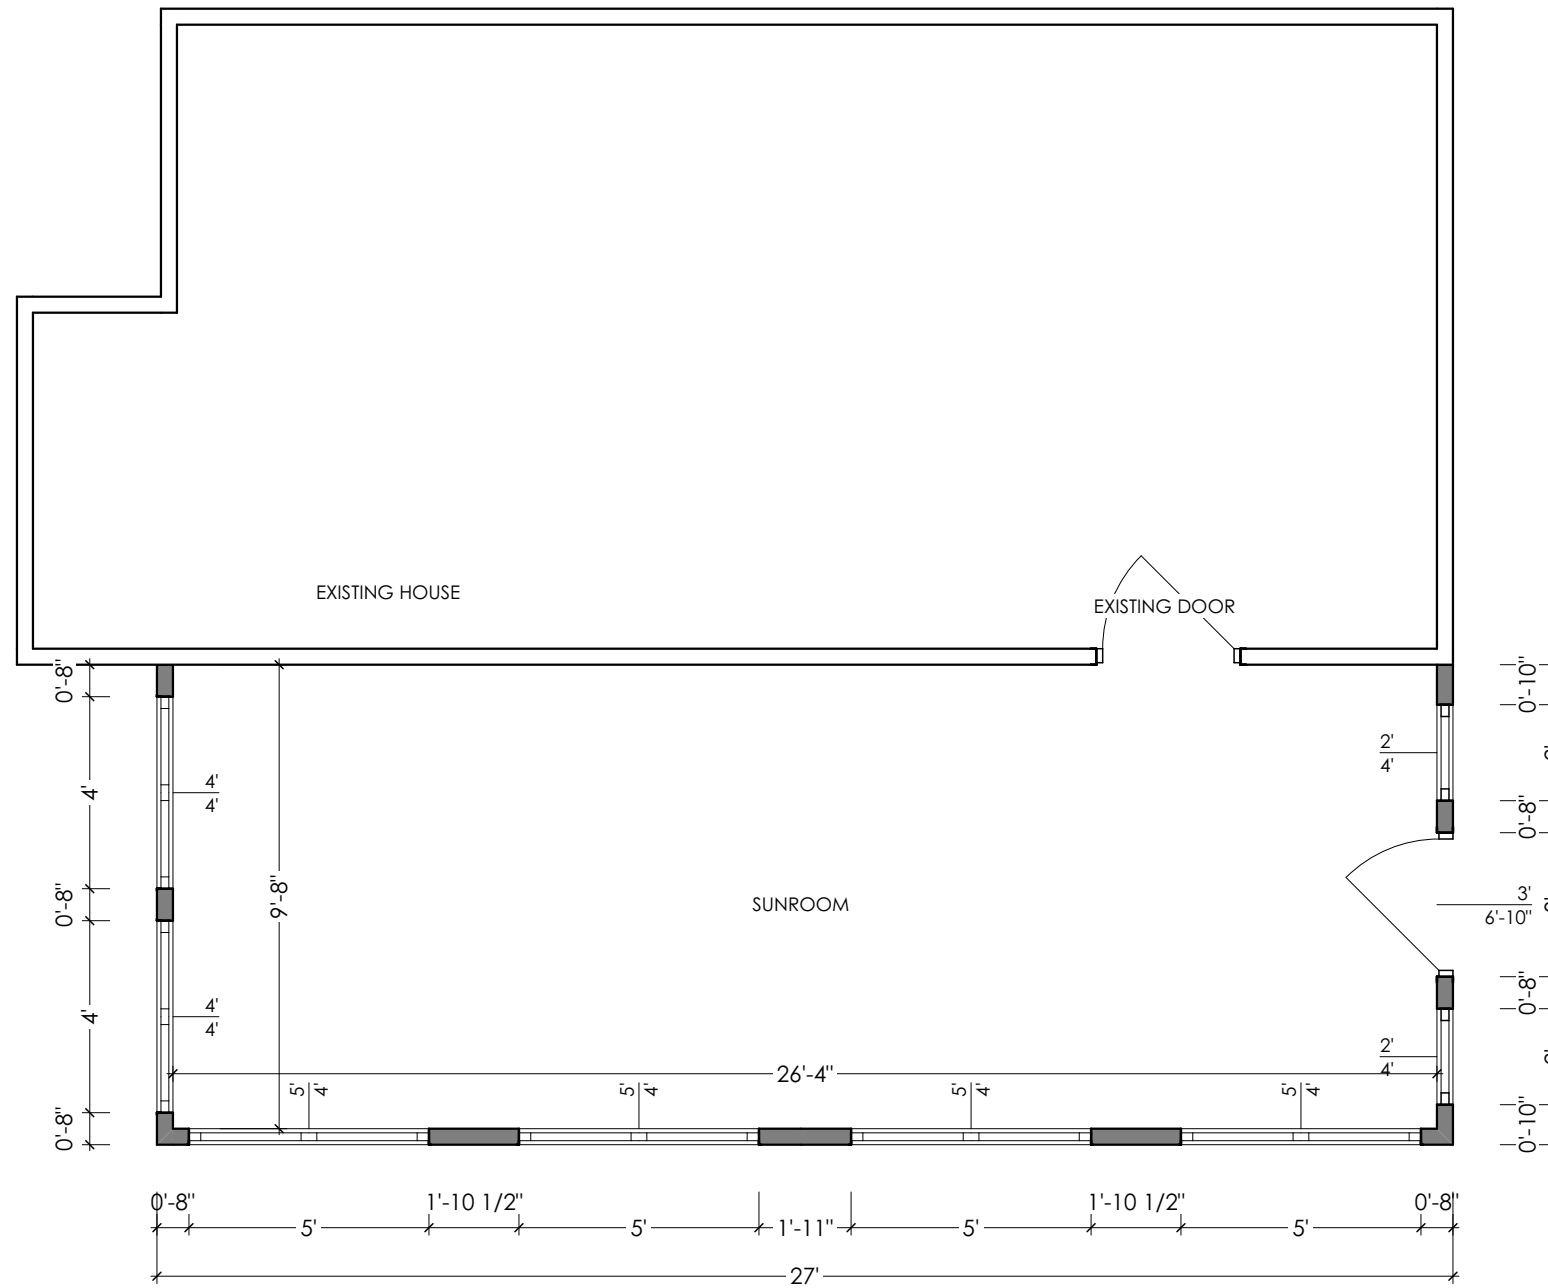

2" x 4" WALLS WITH R 15 INSULATION
2" x 8" HEADERS FOR WINDOWS

MAIN FLOOR PLAN

SCALE 1/4"=1'-0"

SHEET TITLE:

MAIN FLOOR PLAN

PROJECT TITLE:

DECK DESIGN 87

266 S STANWOOD RD

BEXLY, OHIO 43206

DATE:


03/15/2023

SCALE:

1/4"=1FT

SHEET:

P-5

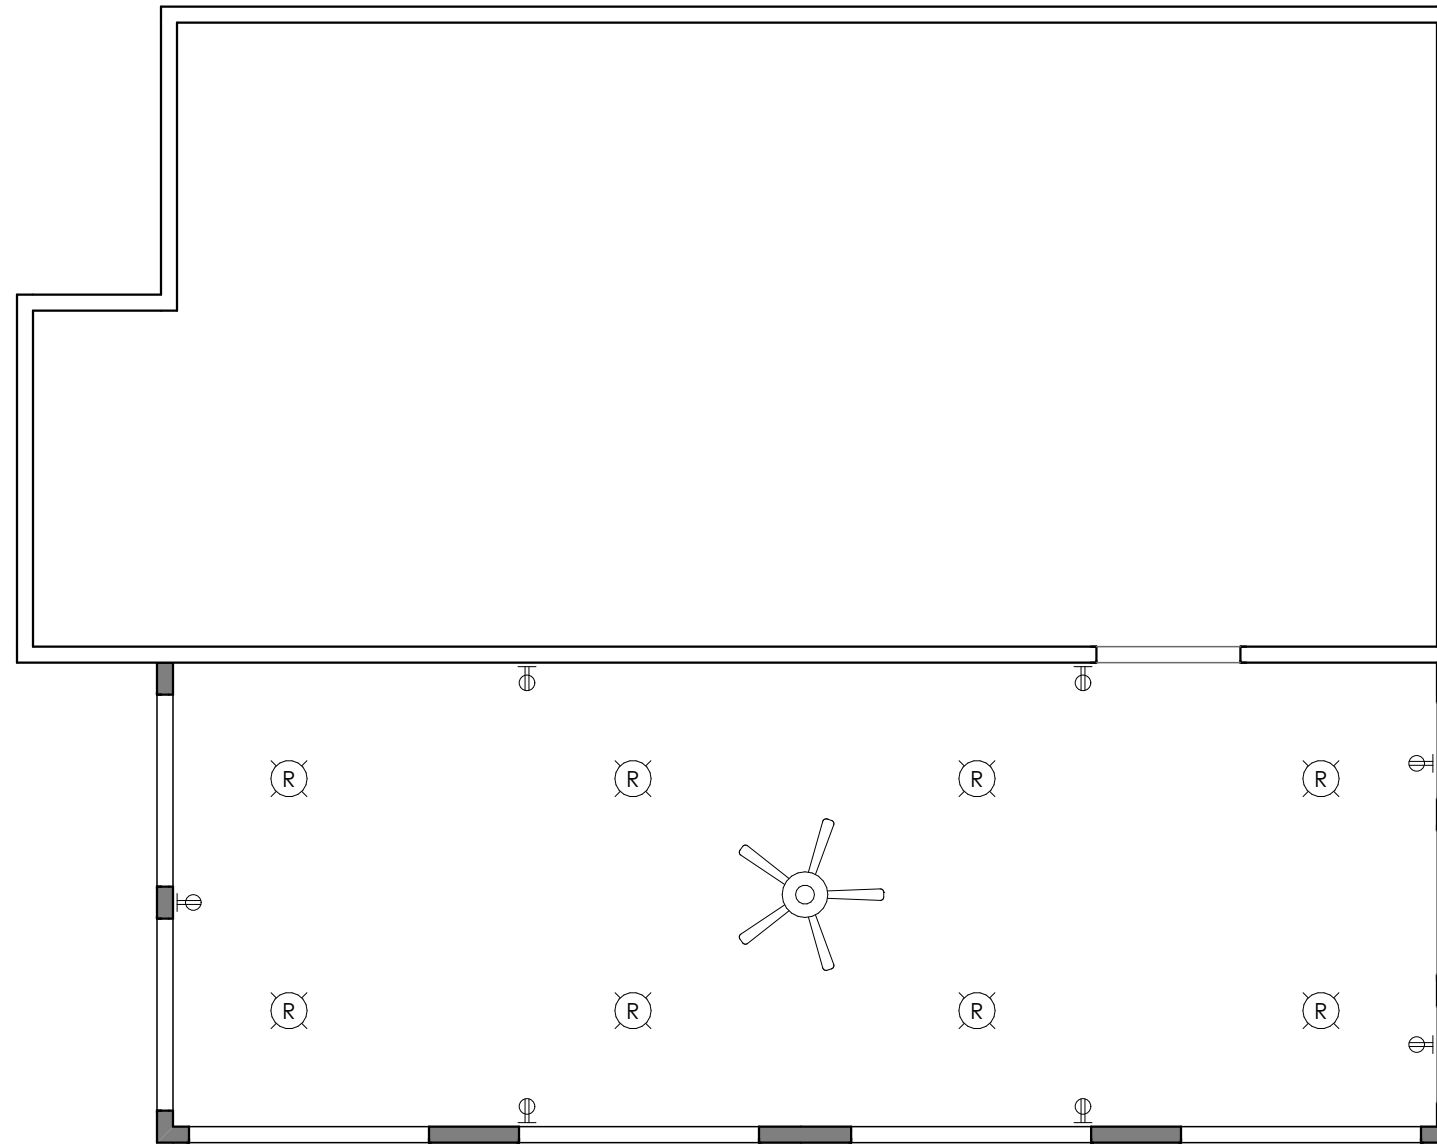

ELECTRICAL SYMBOLS LEGEND	
SYMBOL	DESCRIPTION
	CEILING FAN WITH LIGHT KIT
Ⓡ	RECESSED LIGHT
⊕	110 VOLT OUTLET
⚡	LIGHT SWITCH DOUBLE
⚡	LIGHT SWITCH

GENERAL NOTES:

00" ELEVATION

000 SQ FT

1	REVISION 1	03/15
---	------------	-------

CUSTOM PLAN

SHEET TITLE:
MAIN ELECTRICAL LAYOUT

PROJECT TITLE:
DECK DESIGN 87

266 S STANWOOD RD

BEXLY, OHIO 43206

DATE:

03/15/2023


SCALE:

1/4"=1FT

SHEET:

P-6

ELECTRICAL LAYOUT
SCALE 1/4"=1'-0"

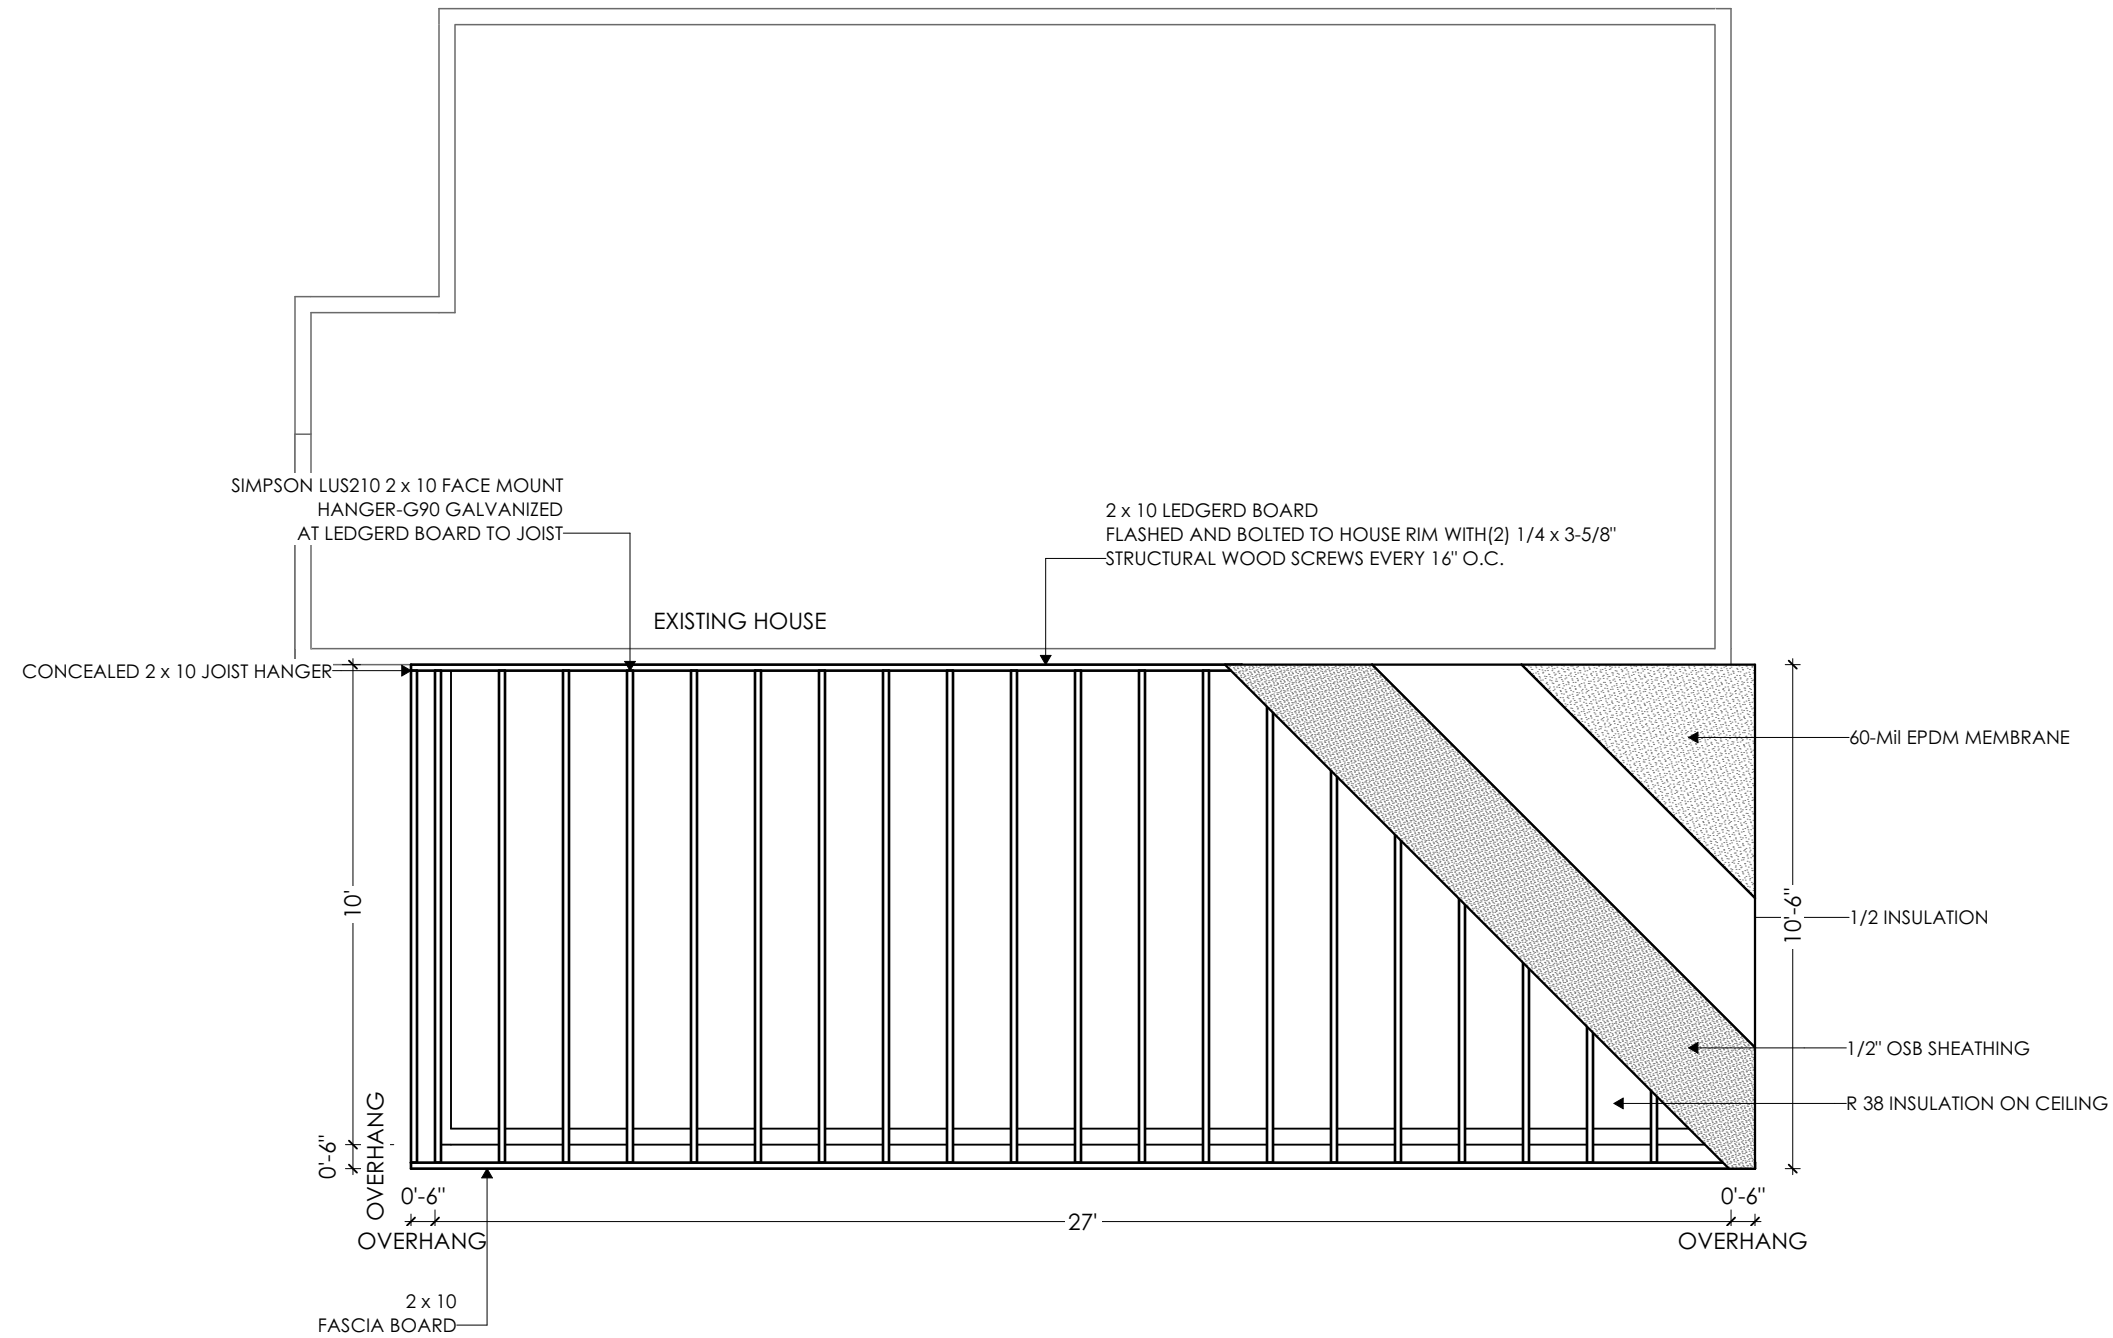

GENERAL NOTES:

00' ELEVATION

000 SQ FT

1	REVISION 1	03/15
---	------------	-------

CUSTOM PLAN

SHEET TITLE: **ROOF FRAMING PLAN**

PROJECT TITLE: **DECK DESIGN 87**

266 S STANWOOD RD

BEXLY, OHIO 43206

DATE:

03/15/2023

SCALE:

1/4"=1FT

SHEET:

P-7

GENERAL NOTES:

00" ELEVATION

000 SQ FT

1	REVISION 1	03/15
---	------------	-------

CUSTOM PLAN

SHEET TITLE:	FRONT ELEVATION
	DECK DESIGN 87
PROJECT TITLE:	266 S STANWOOD RD
	BEXLY, OHIO 43206

DATE:
03/15/2023

SCALE:
1/4"=1FT

SHEET:
P-8





GENERAL NOTES:

00' ELEVATION

000 SQ FT

1	REVISION 1	03/15
---	------------	-------

CUSTOM PLAN

SHEET TITLE:	SIDE ELEVATION
PROJECT TITLE:	DECK DESIGN 87
	266 S STANWOOD RD
	BEXLY, OHIO 43206

DATE:

03/15/2023


SCALE:

1/4"=1FT

SHEET:

P-9

GENERAL NOTES:

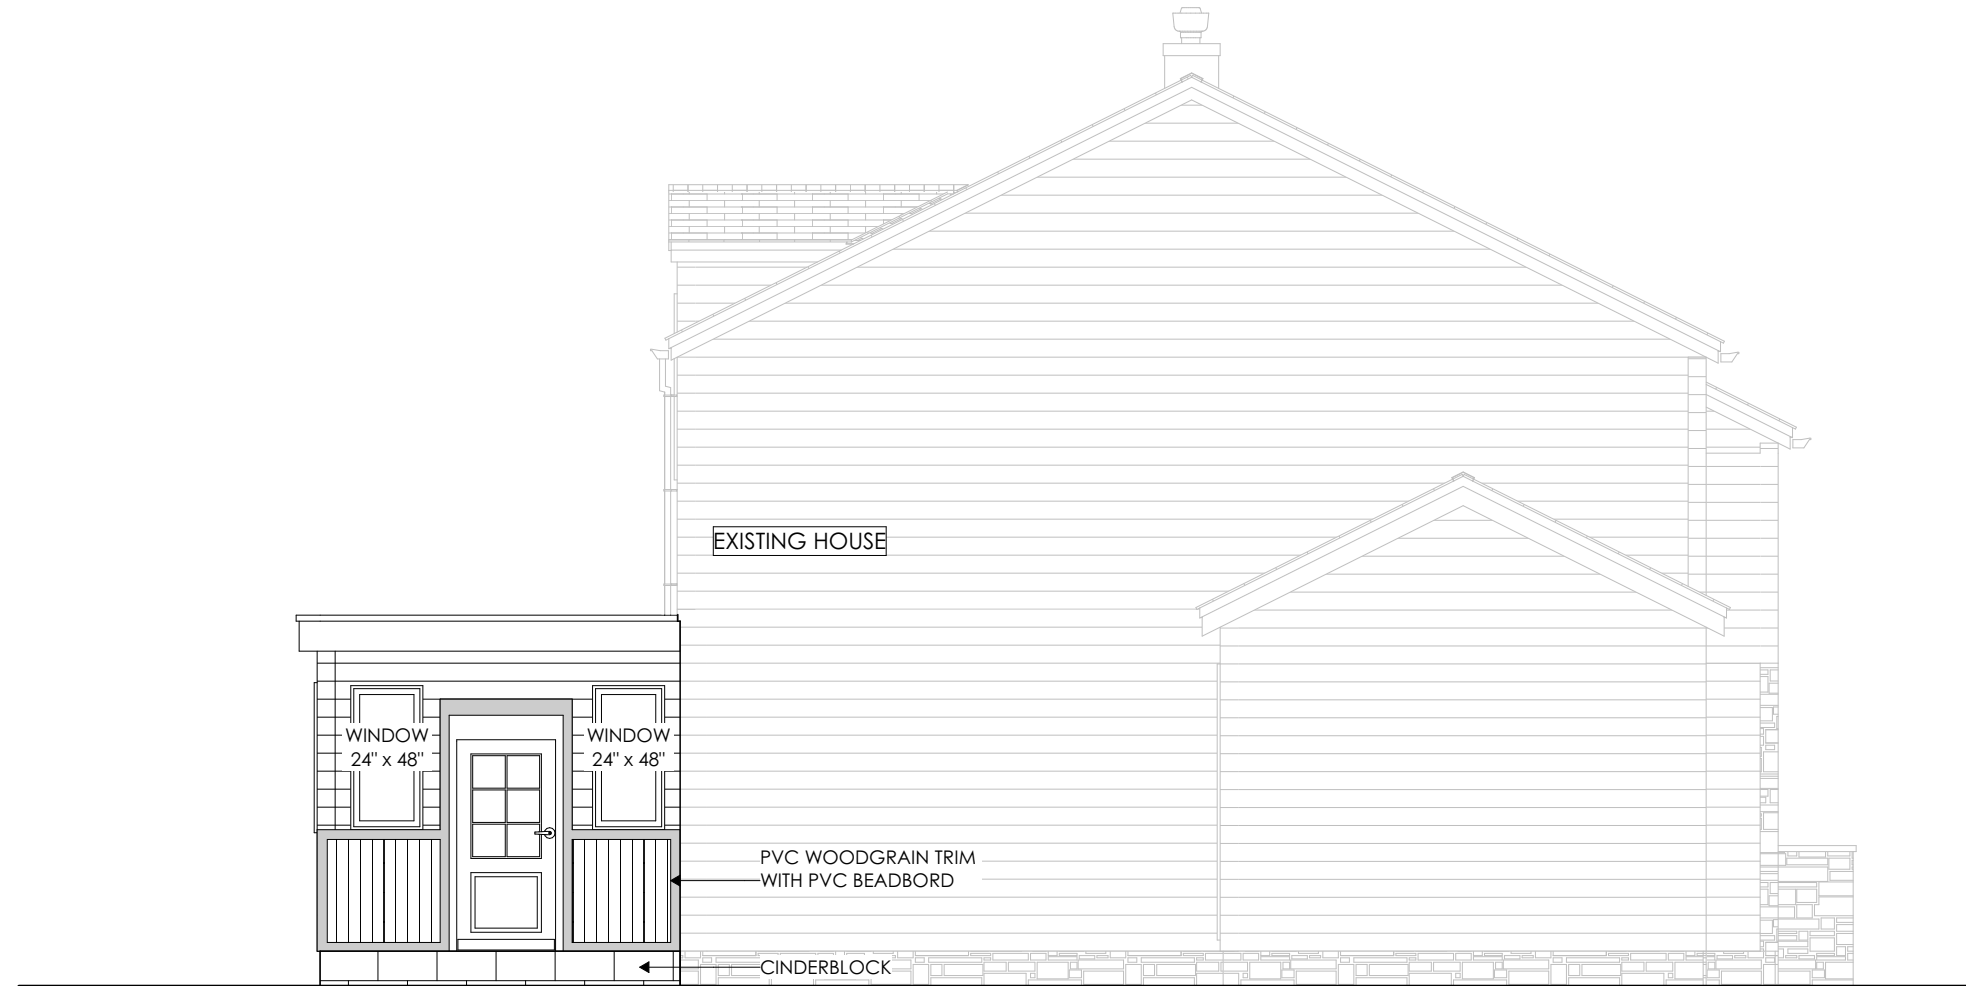

00' ELEVATION

000 SQ FT

1	REVISION 1	03/15
---	------------	-------

CUSTOM PLAN

SHEET TITLE: SIDE ELEVATION	PROJECT TITLE: DECK DESIGN 87	266 S STANWOOD RD	BEXLY, OHIO 43206

DATE:


03/15/2023

SCALE:

1/4"=1FT

SHEET:

P-10

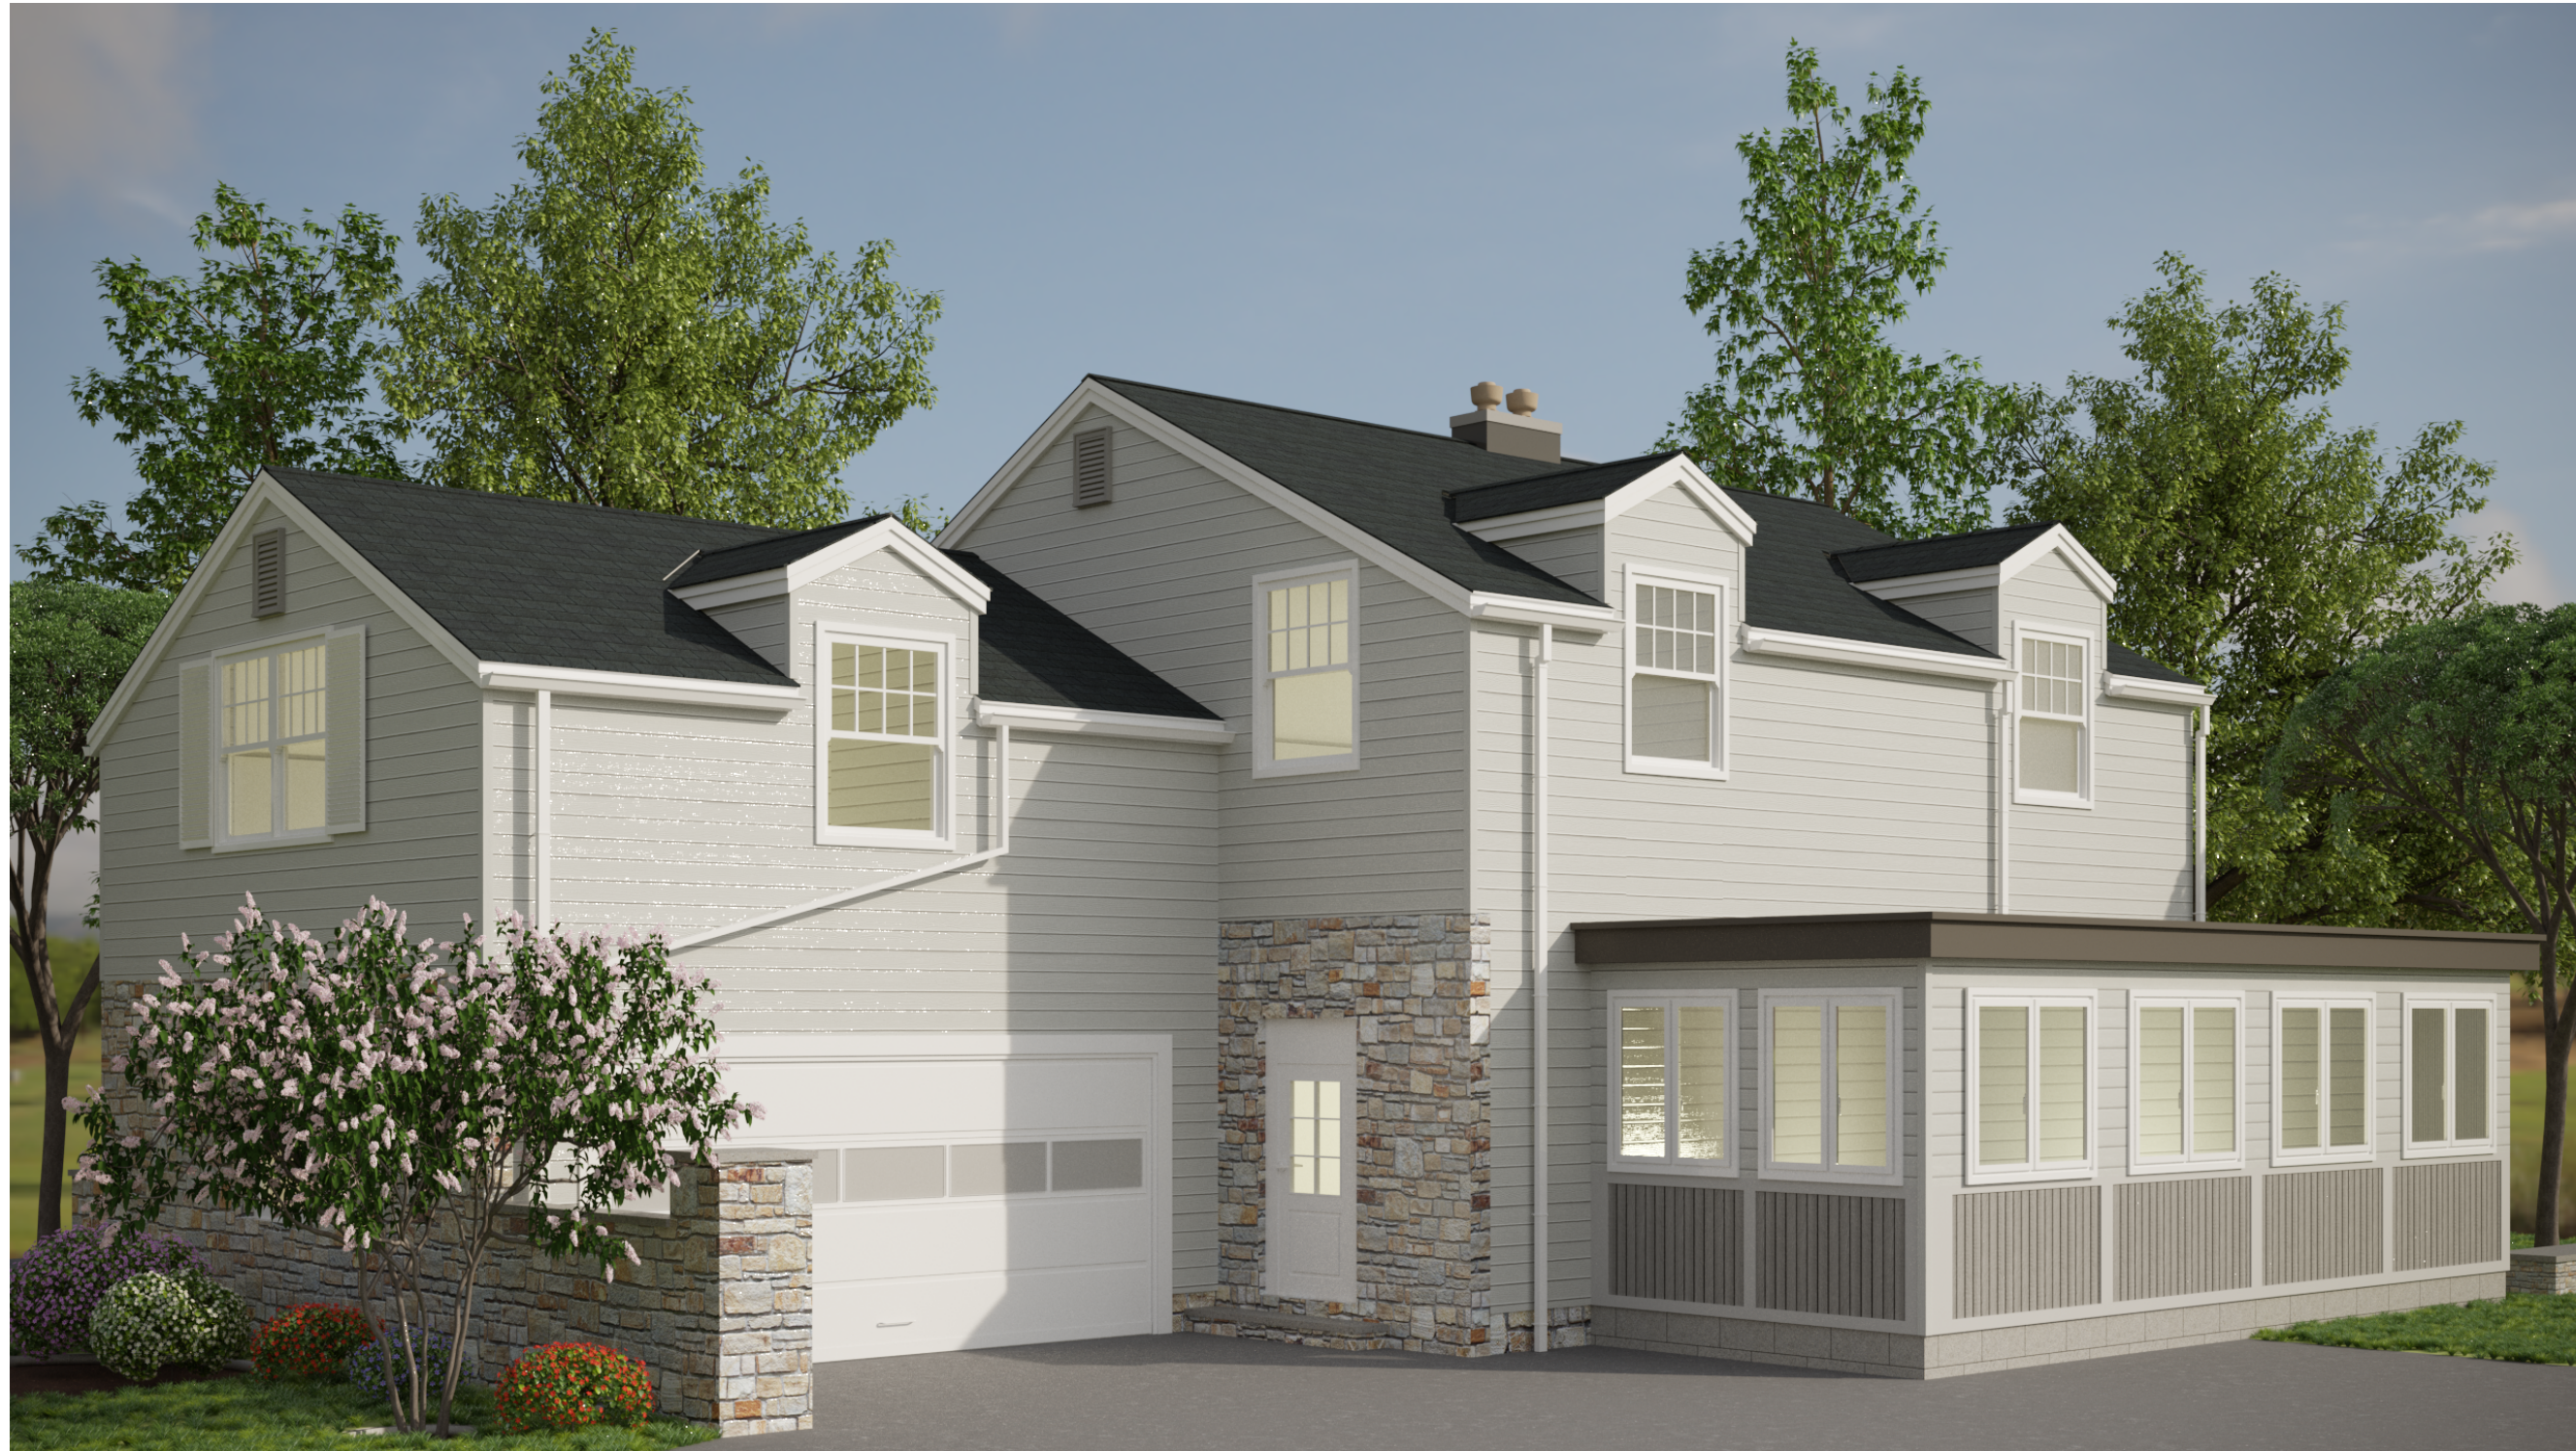

GENERAL NOTES:

00" ELEVATION

000 SQ FT

1	REVISION 1	03/15
---	------------	-------

CUSTOM PLAN

SHEET TITLE:
RENDERING

PROJECT TITLE:
DECK DESIGN 87

266 S STANWOOD RD

BEXLY, OHIO 43206

DATE:

03/15/2023

SCALE:

1/4"=1FT

SHEET:

P-11