


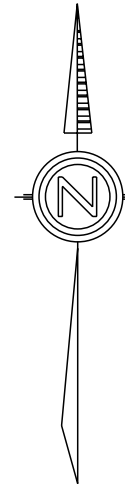


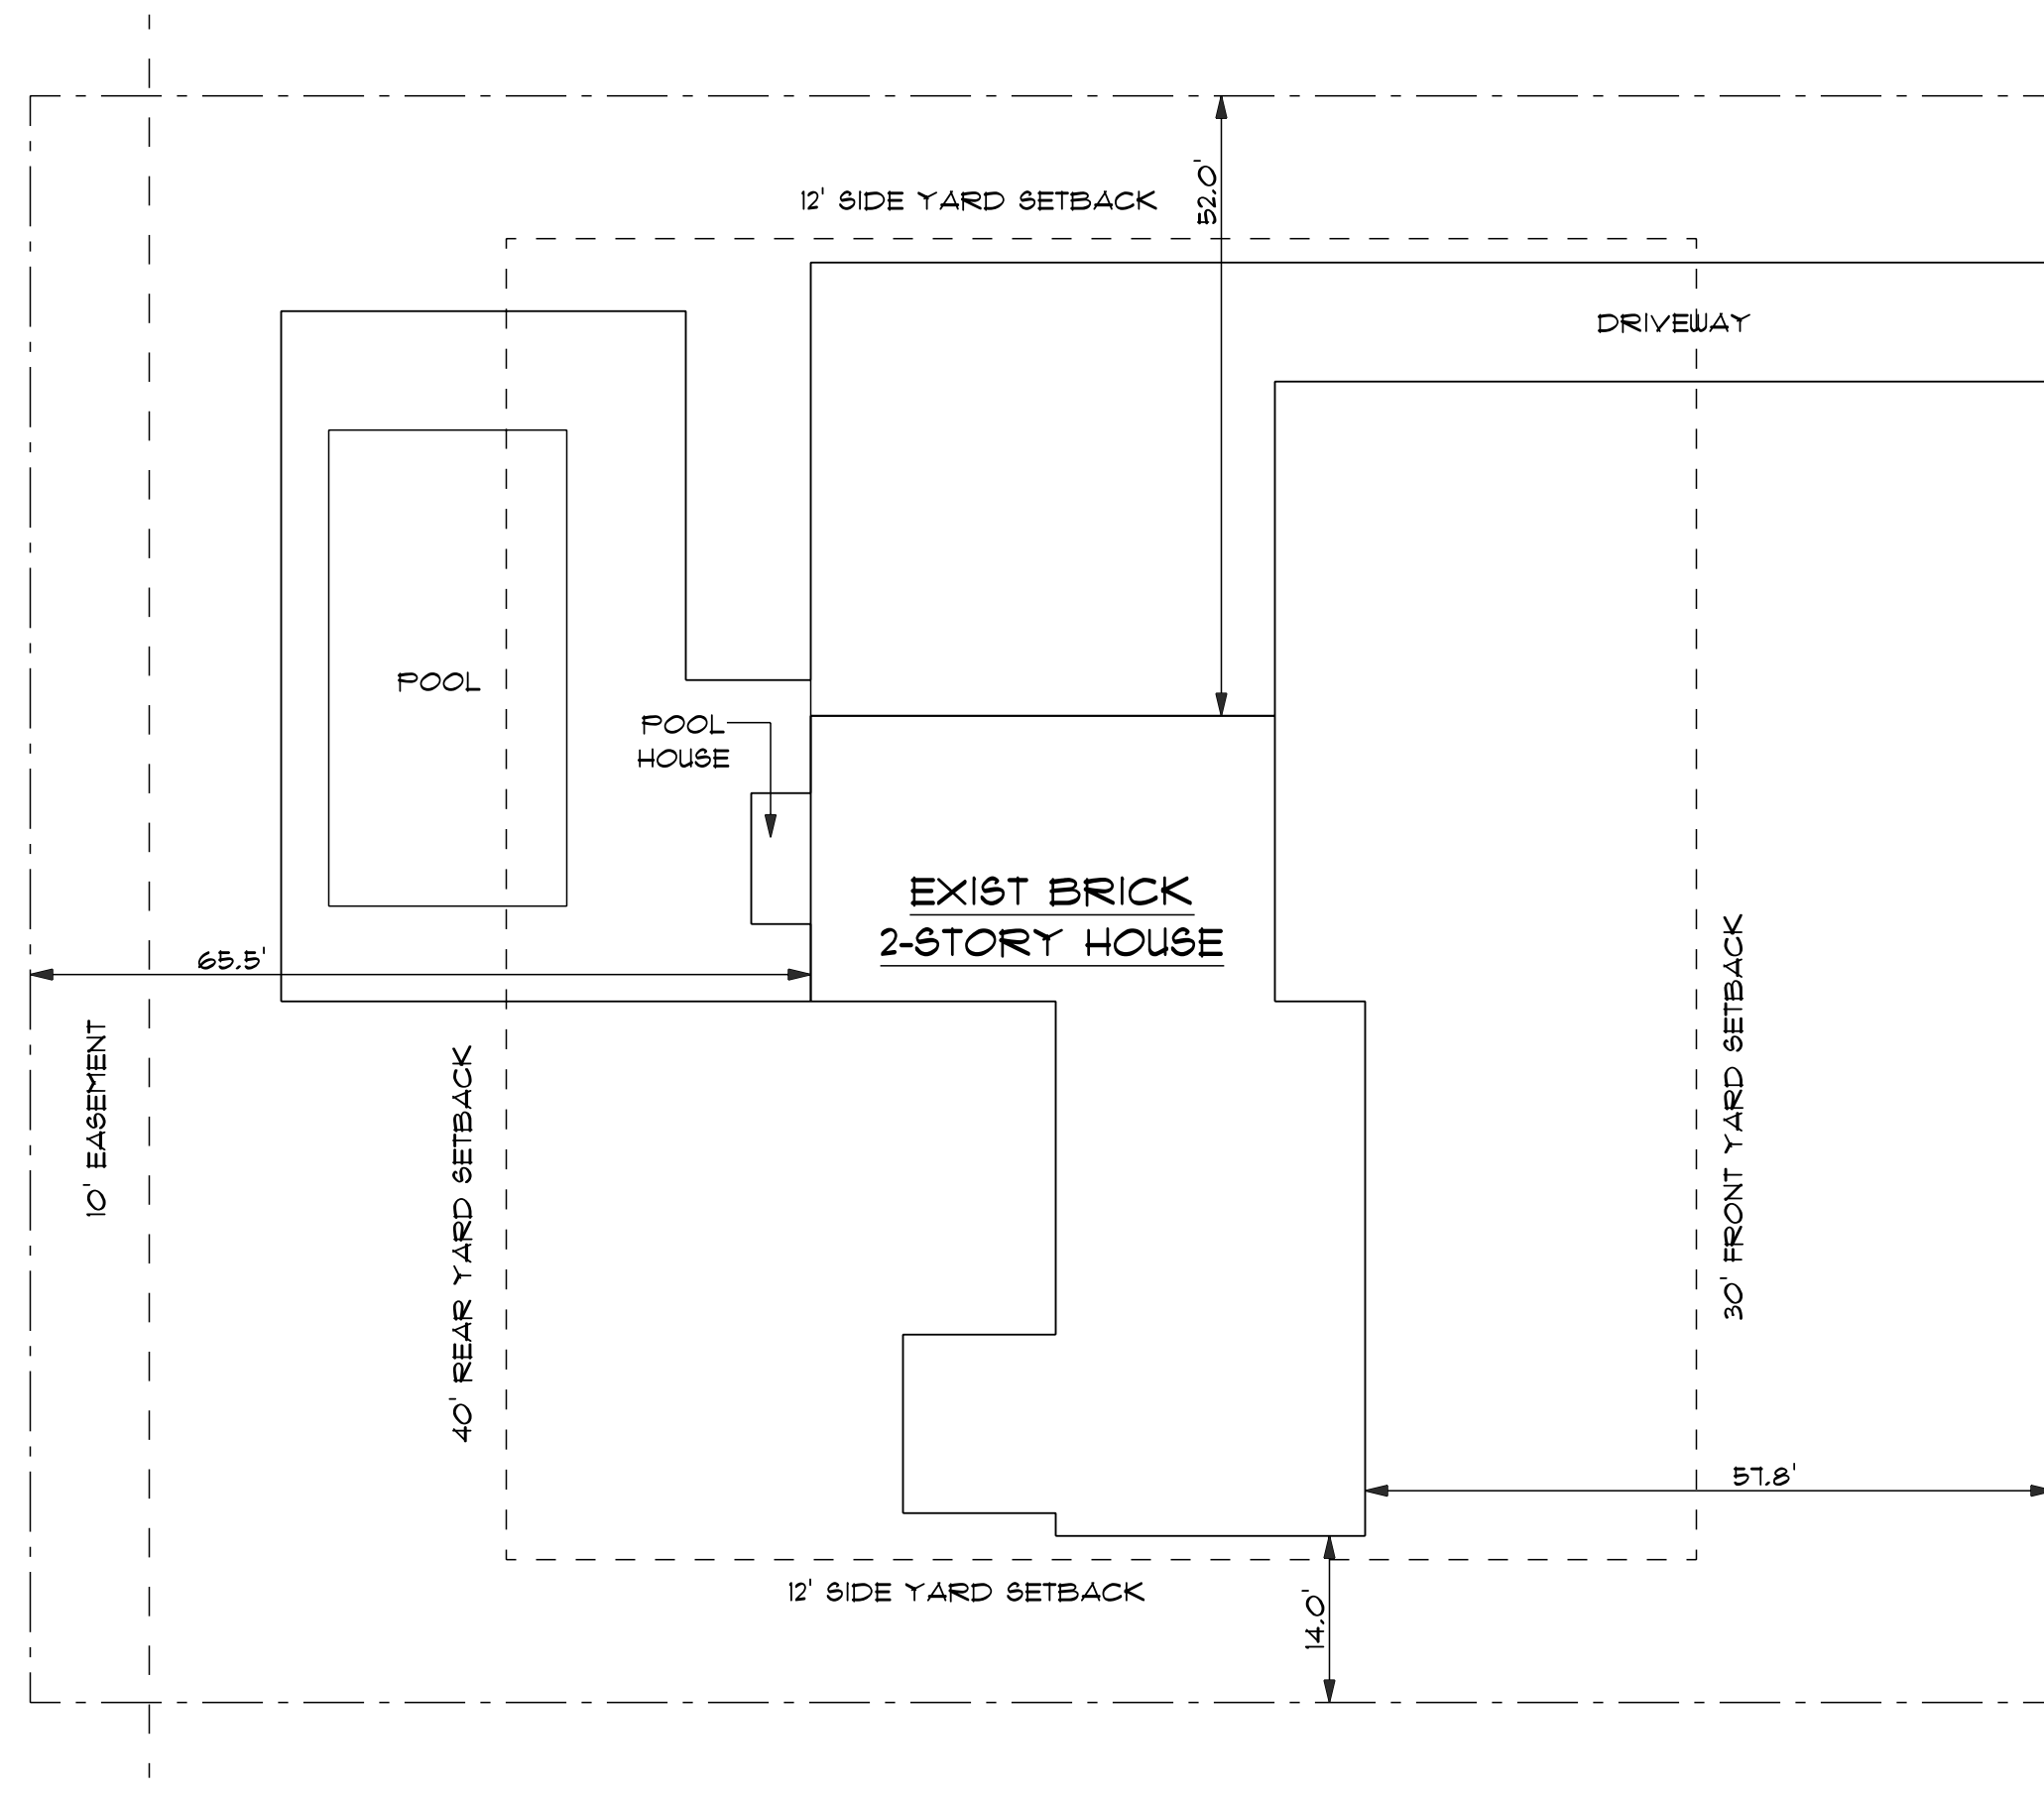

EXISTING SITE PLAN

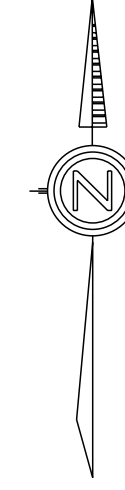

NEW SITE PLAN

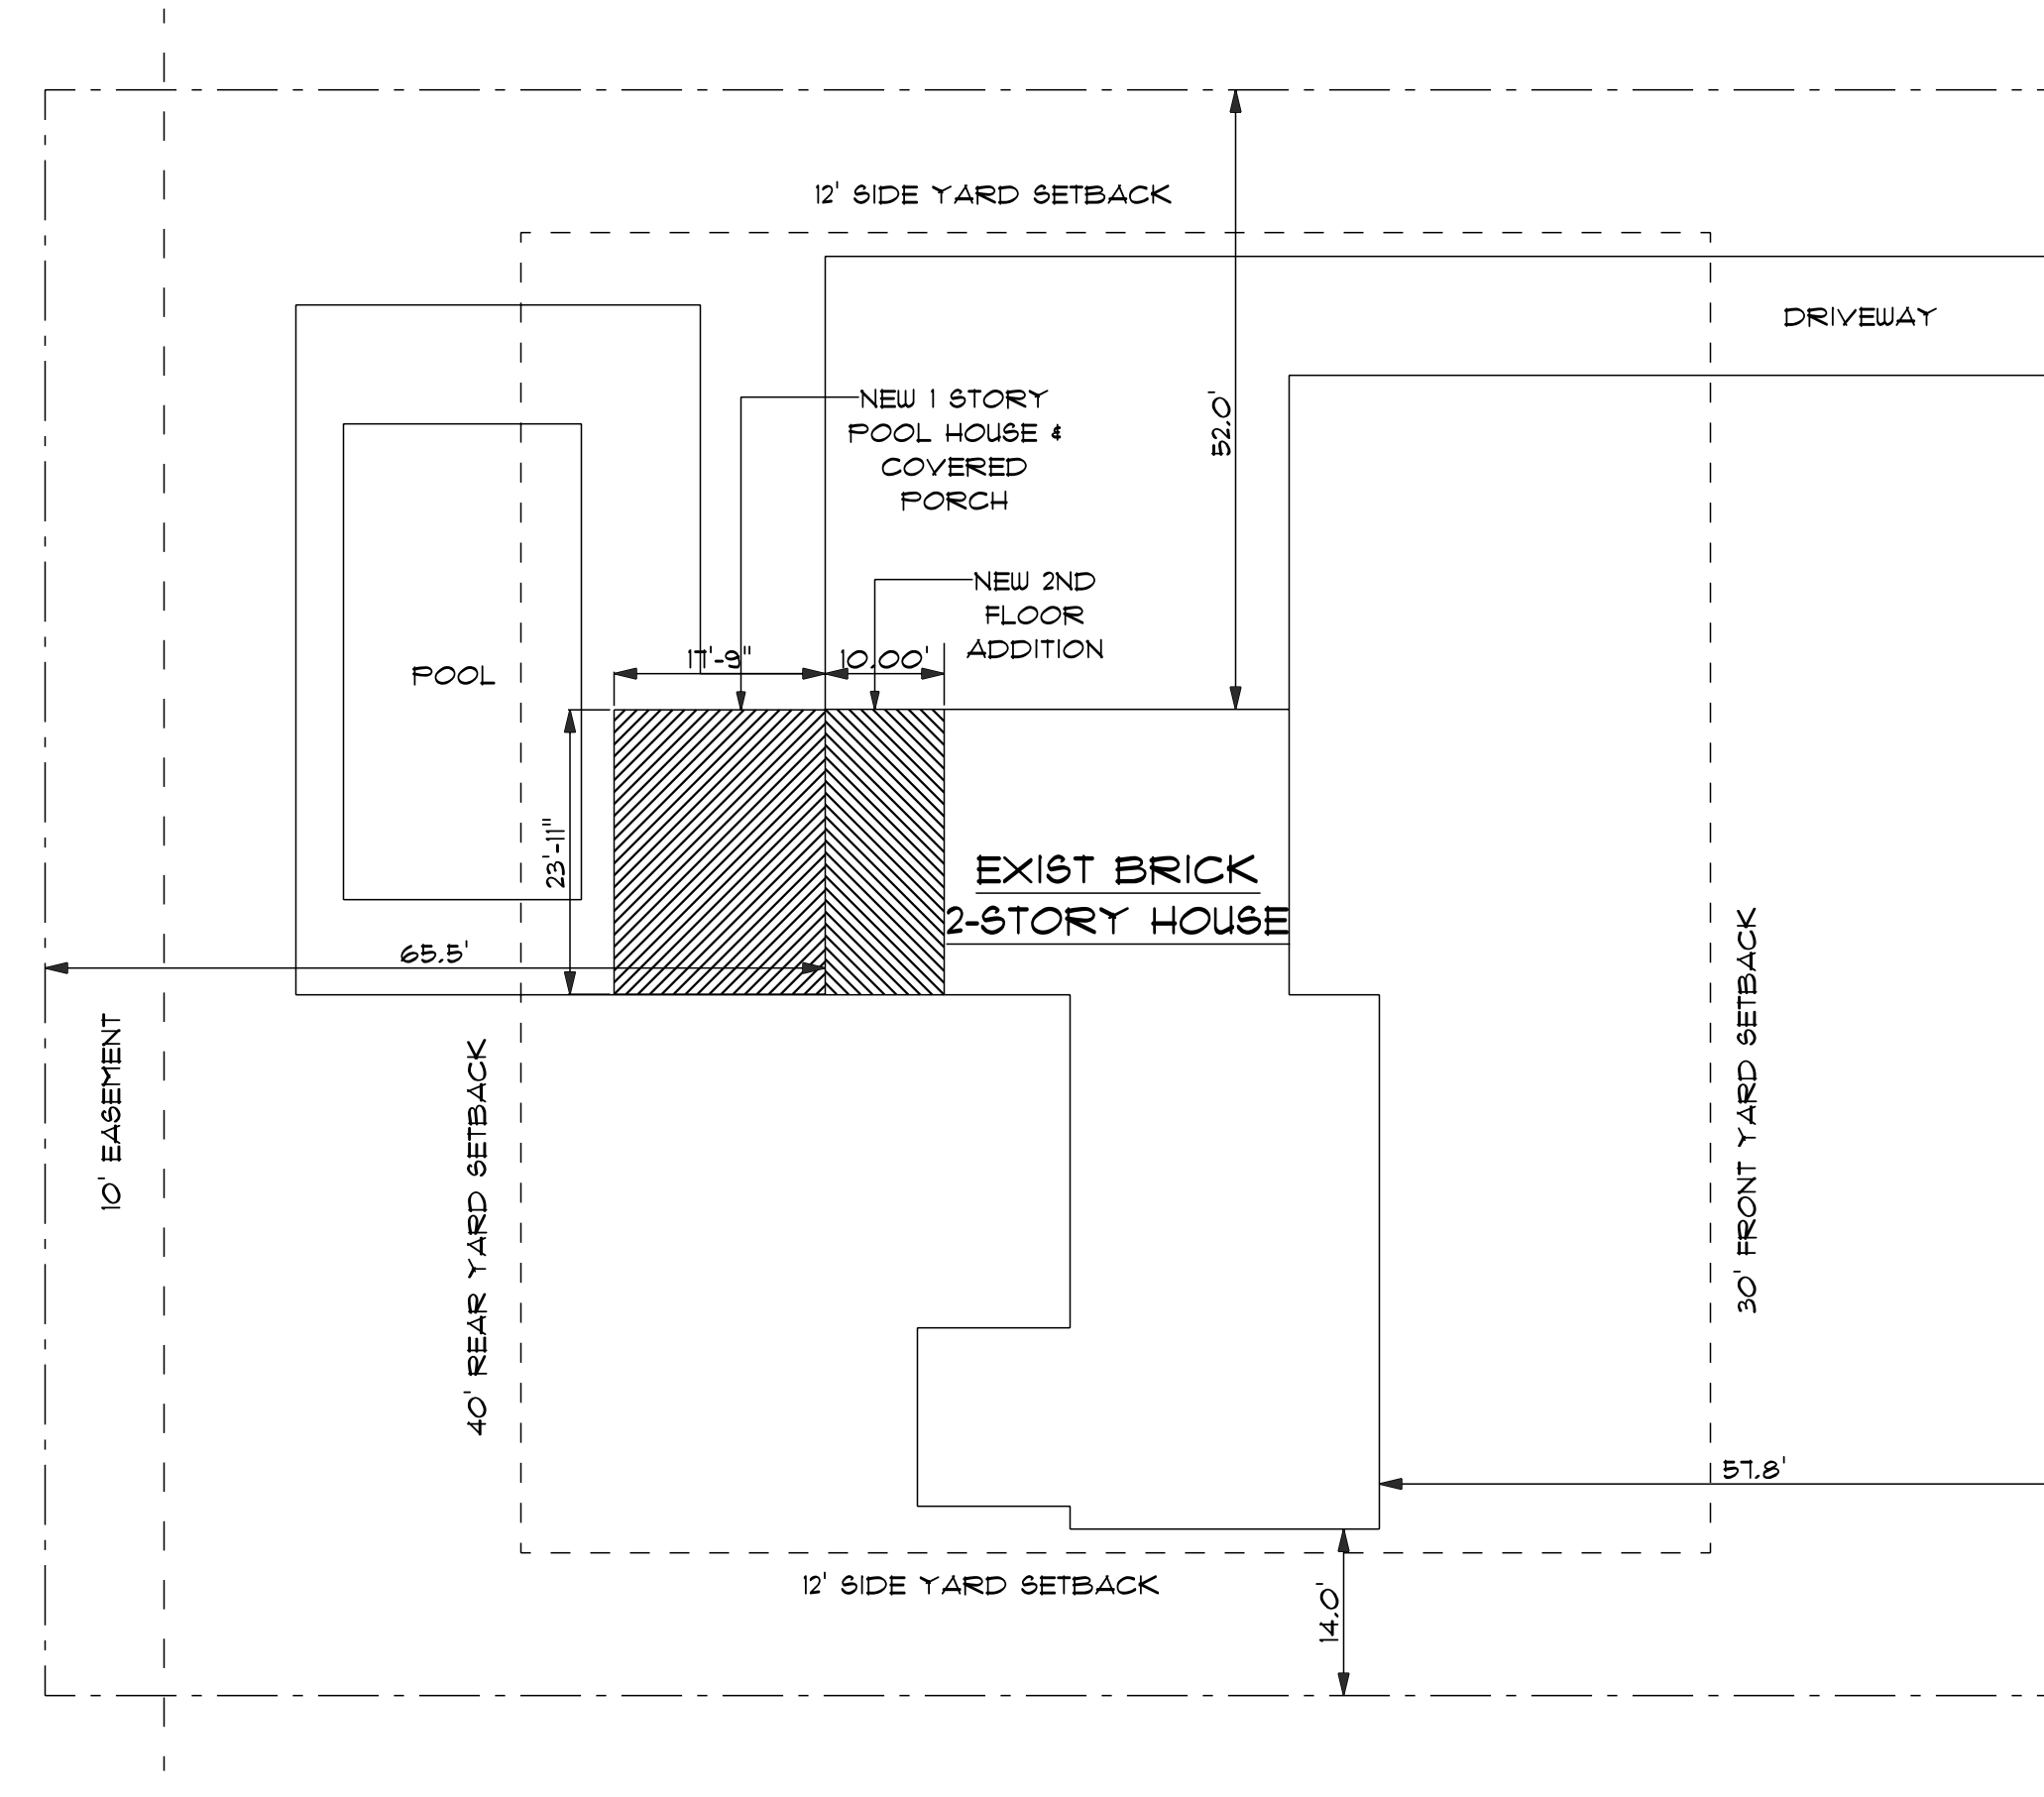

COORDINATE ALL FRAMING, CABINET LAYOUTS & FINAL FINISHES w/ DFR ID & DC PRIOR TO INSTALLATION

FIELD VERIFY ALL EXISTING CONDITIONS & DIMENSIONS PRIOR TO CONSTRUCTION ANY VARIATIONS SHOULD BE REPORTED TO THE PM & DC

Scale: 1/4" = 1' (unless otherwise noted)

REVISION	DATE	DESCRIPTION

DESIGNED BY: JENNIFER ZIFFEL  
 ID BY: FAITH HERRING  
 PM BY: T.B.D.  
 PROJ. # 2200000  
 DATE 00.00.22  
**SITE PLAN**  
 SHEET #  
 1 of 2


A-0

DANIELLE DEMKO & AMAN GARCHA RESIDENCE  
 125 ASHBOURNE RD, BEXLEY, OH 43209


**DAVE FOX**  
 DESIGN • BUILD • REMODELERS  
 3505 W. Dublin-Granville Rd, Columbus, OH 43235  
 www.davefox.com 614-459-7211

Approved by: \_\_\_\_\_  
 Date: \_\_\_\_\_  
 Owner: \_\_\_\_\_  
 Date: \_\_\_\_\_

Design Plans: For use by agents of DFR only. Use of or modifications of these plans without express permission of DFR is strictly prohibited. Mechanical plans to be verified by licensed contractor.

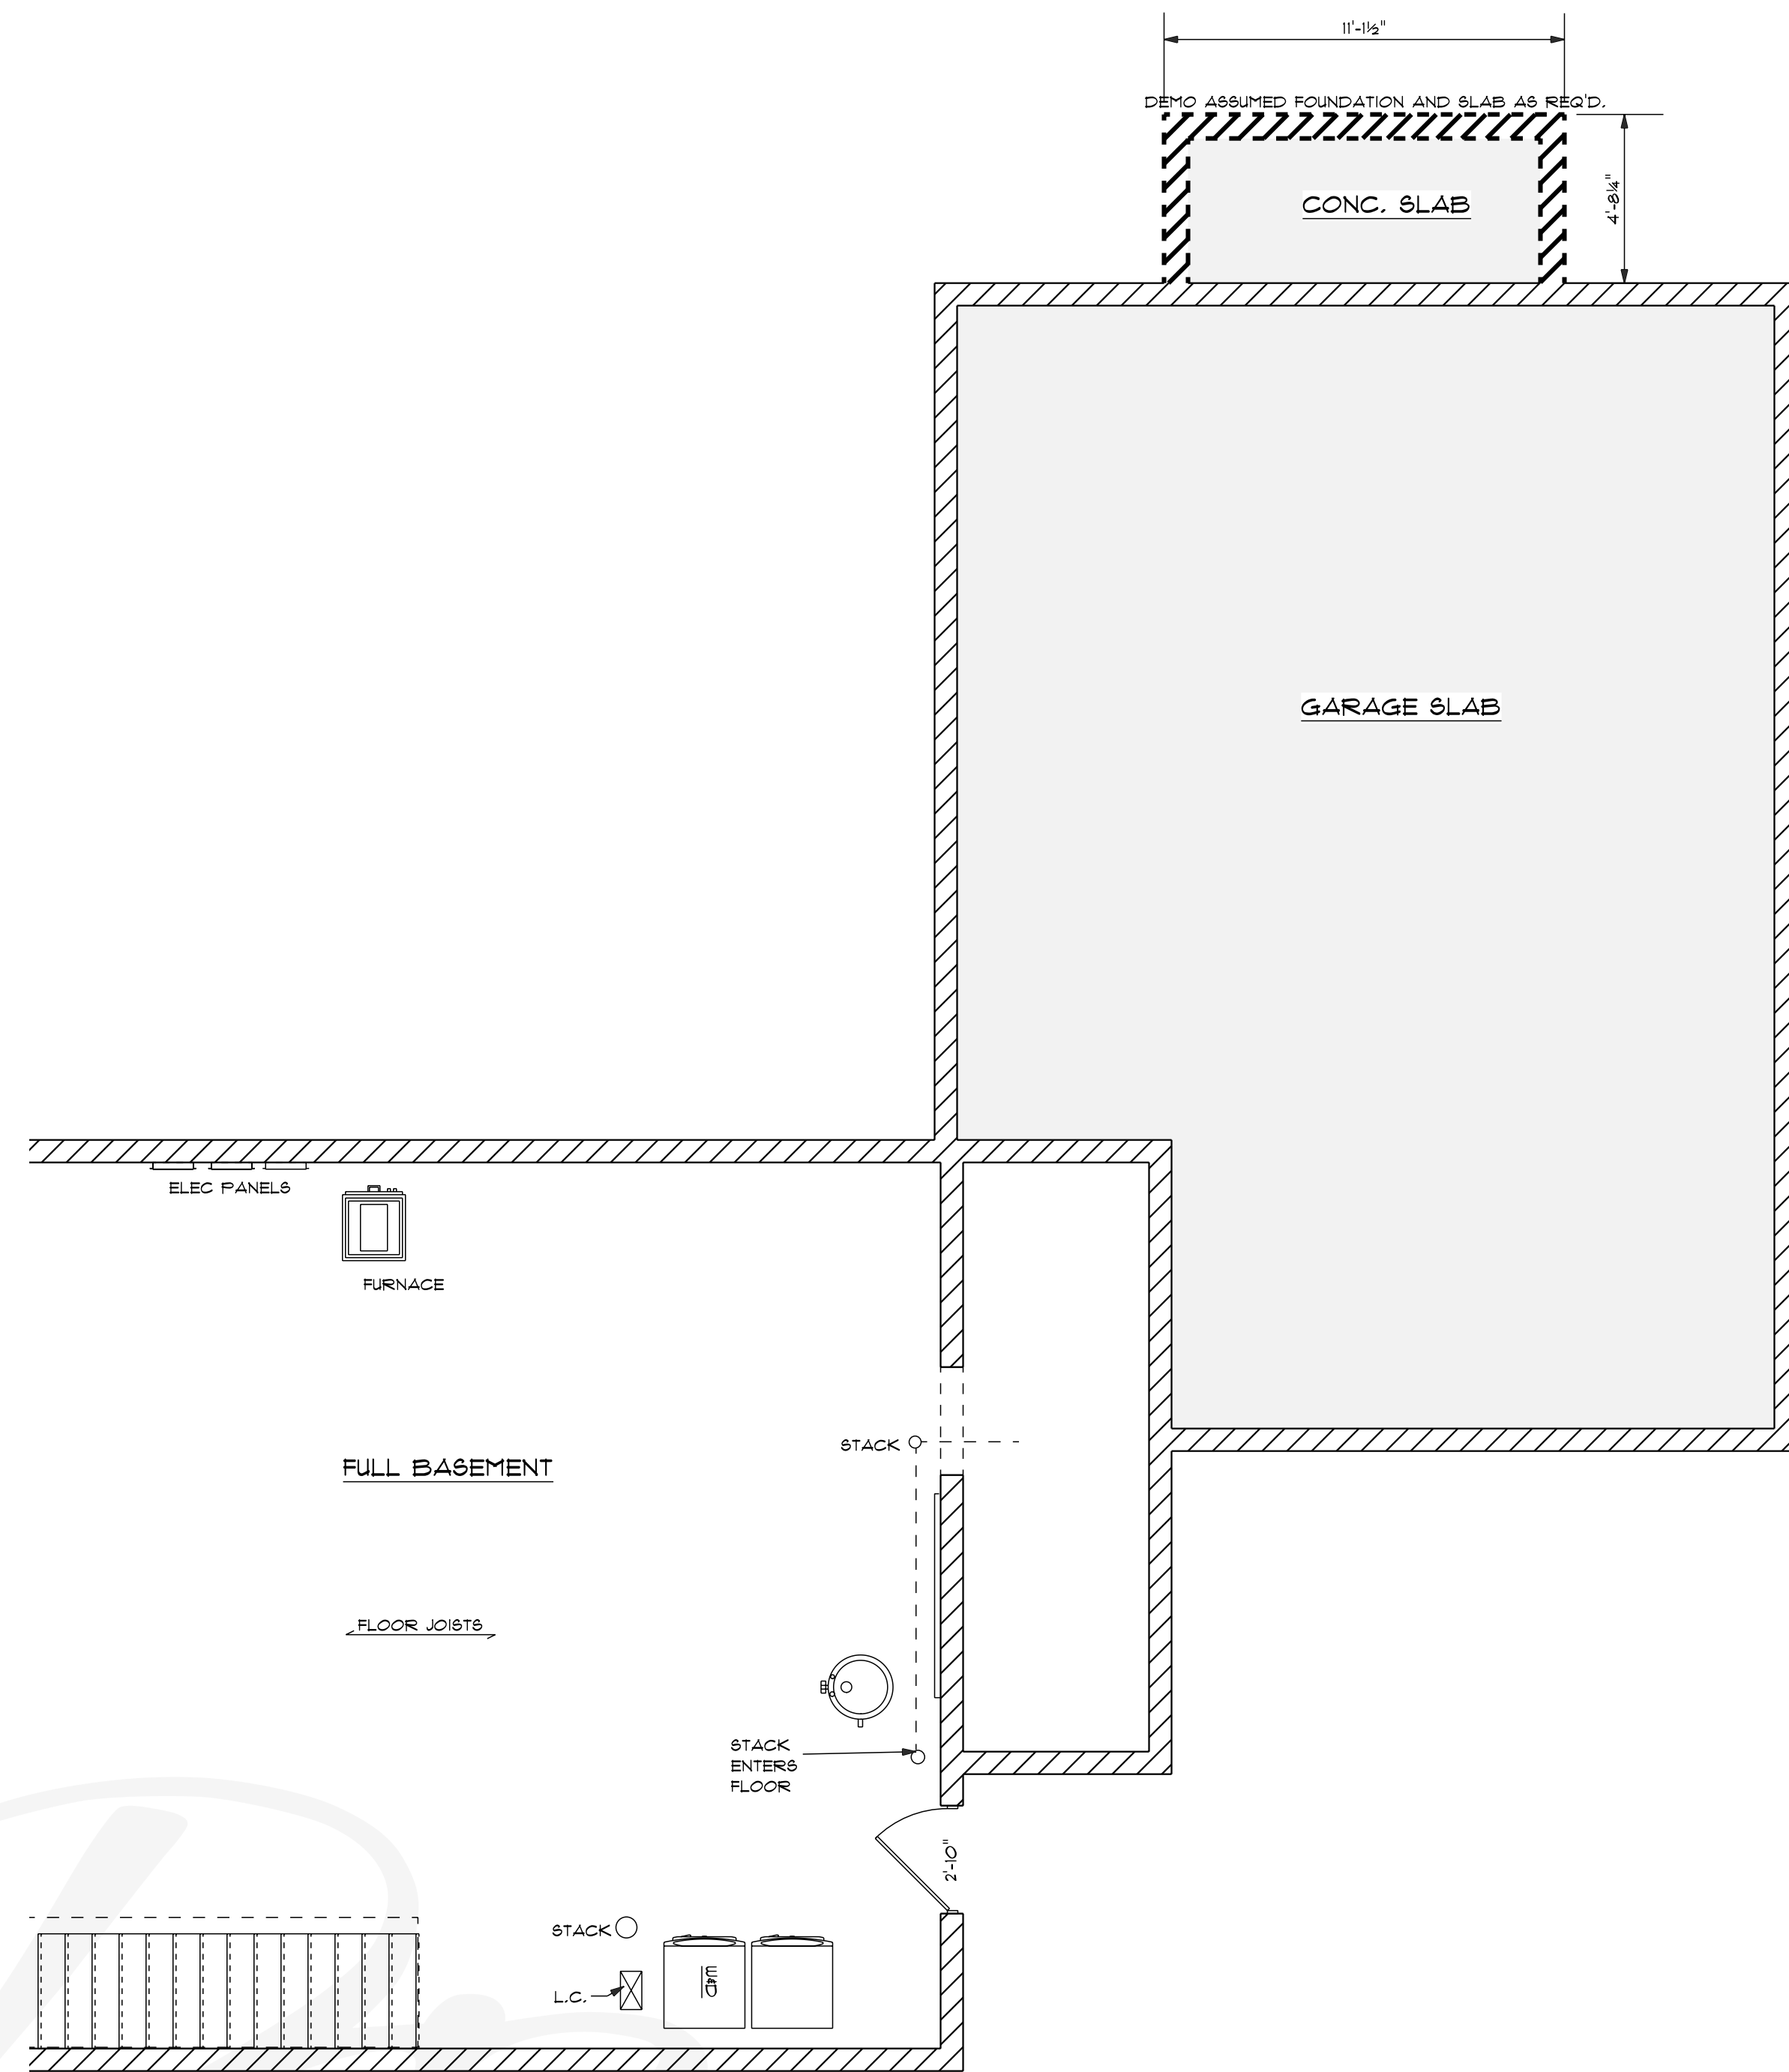

EXISTING FOUNDATION PLAN

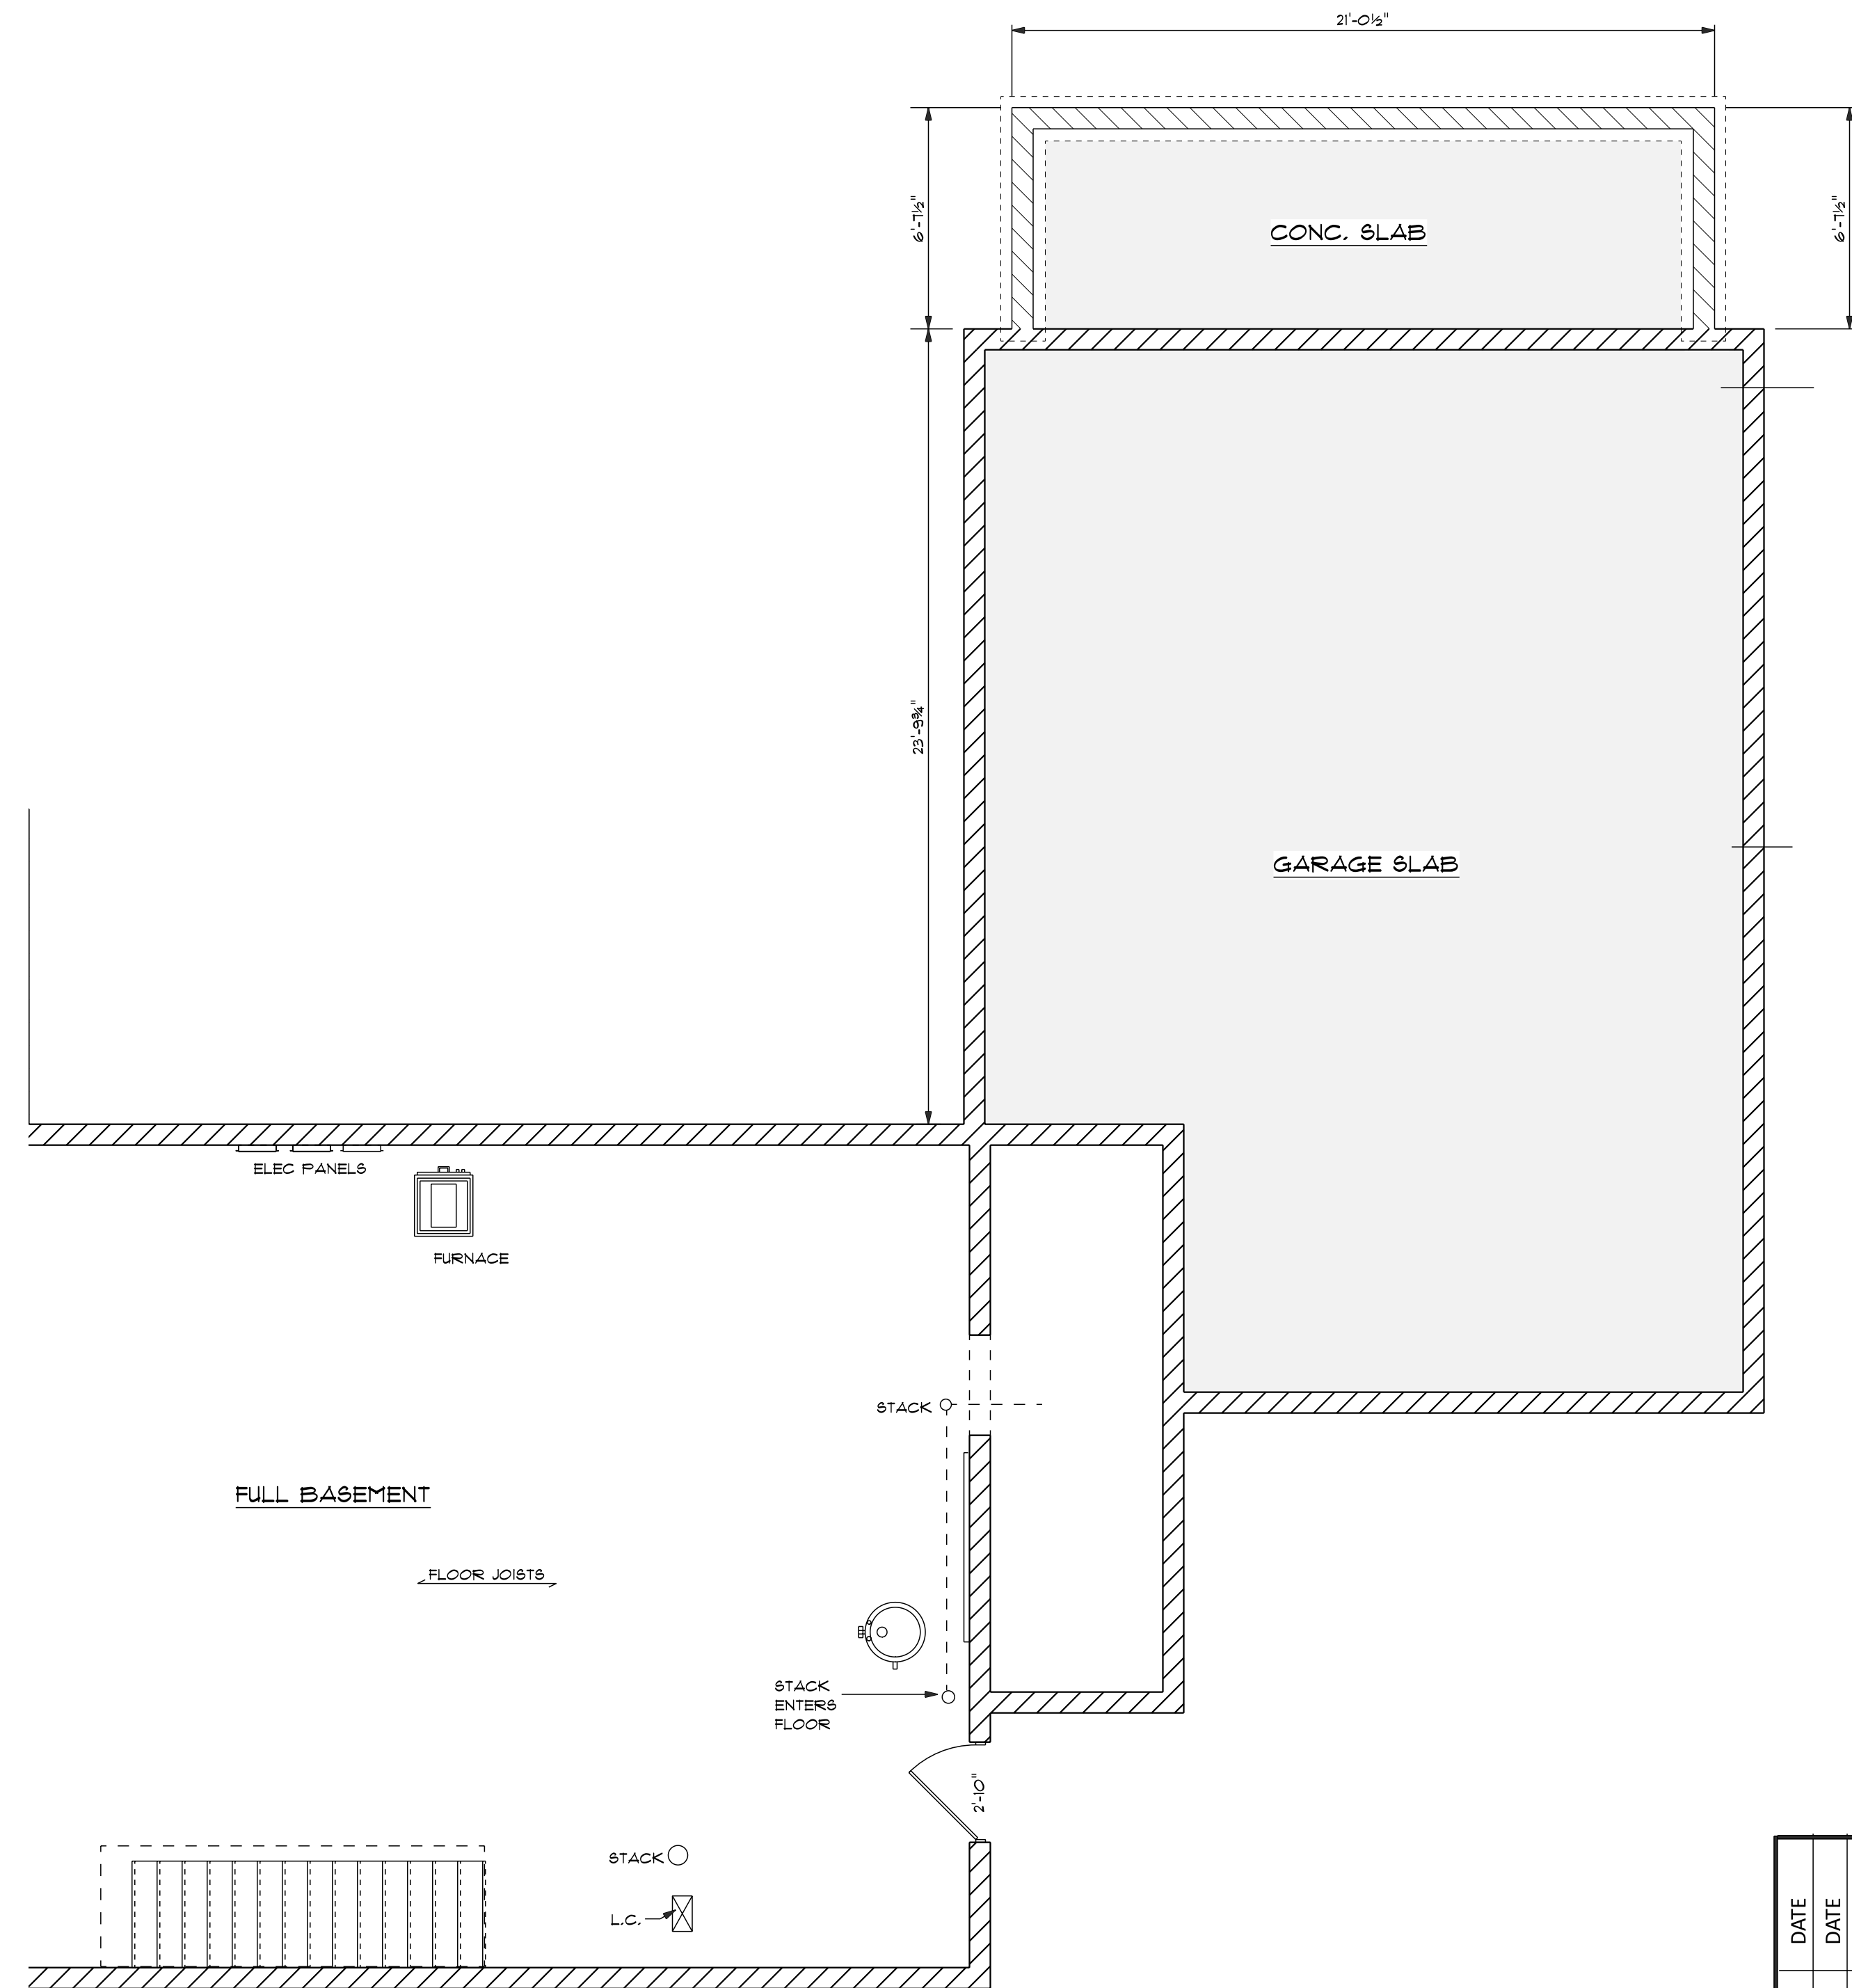

NEW FOUNDATION PLAN

COORDINATE ALL FRAMING, CABINET LAYOUTS & FINAL FINISHES w/ DFR ID & DC PRIOR TO INSTALLATION


FIELD VERIFY ALL EXISTING CONDITIONS & DIMENSIONS PRIOR TO CONSTRUCTION ANY VARIATIONS SHOULD BE REPORTED TO THE PM & DC

REVISION	DATE	DESCRIPTION


DESIGNED BY: JENNIFER ZIFFEL  
 ID BY: FAITH HERRING  
 PM BY: T.B.D.  
 PROJ. # 2200000  
 DATE 00.00.22  
**AS-BUILT PLAN**  
 SHEET #  
 1 of 2

A-1

Scale: 1/4" = 1' (unless otherwise noted)

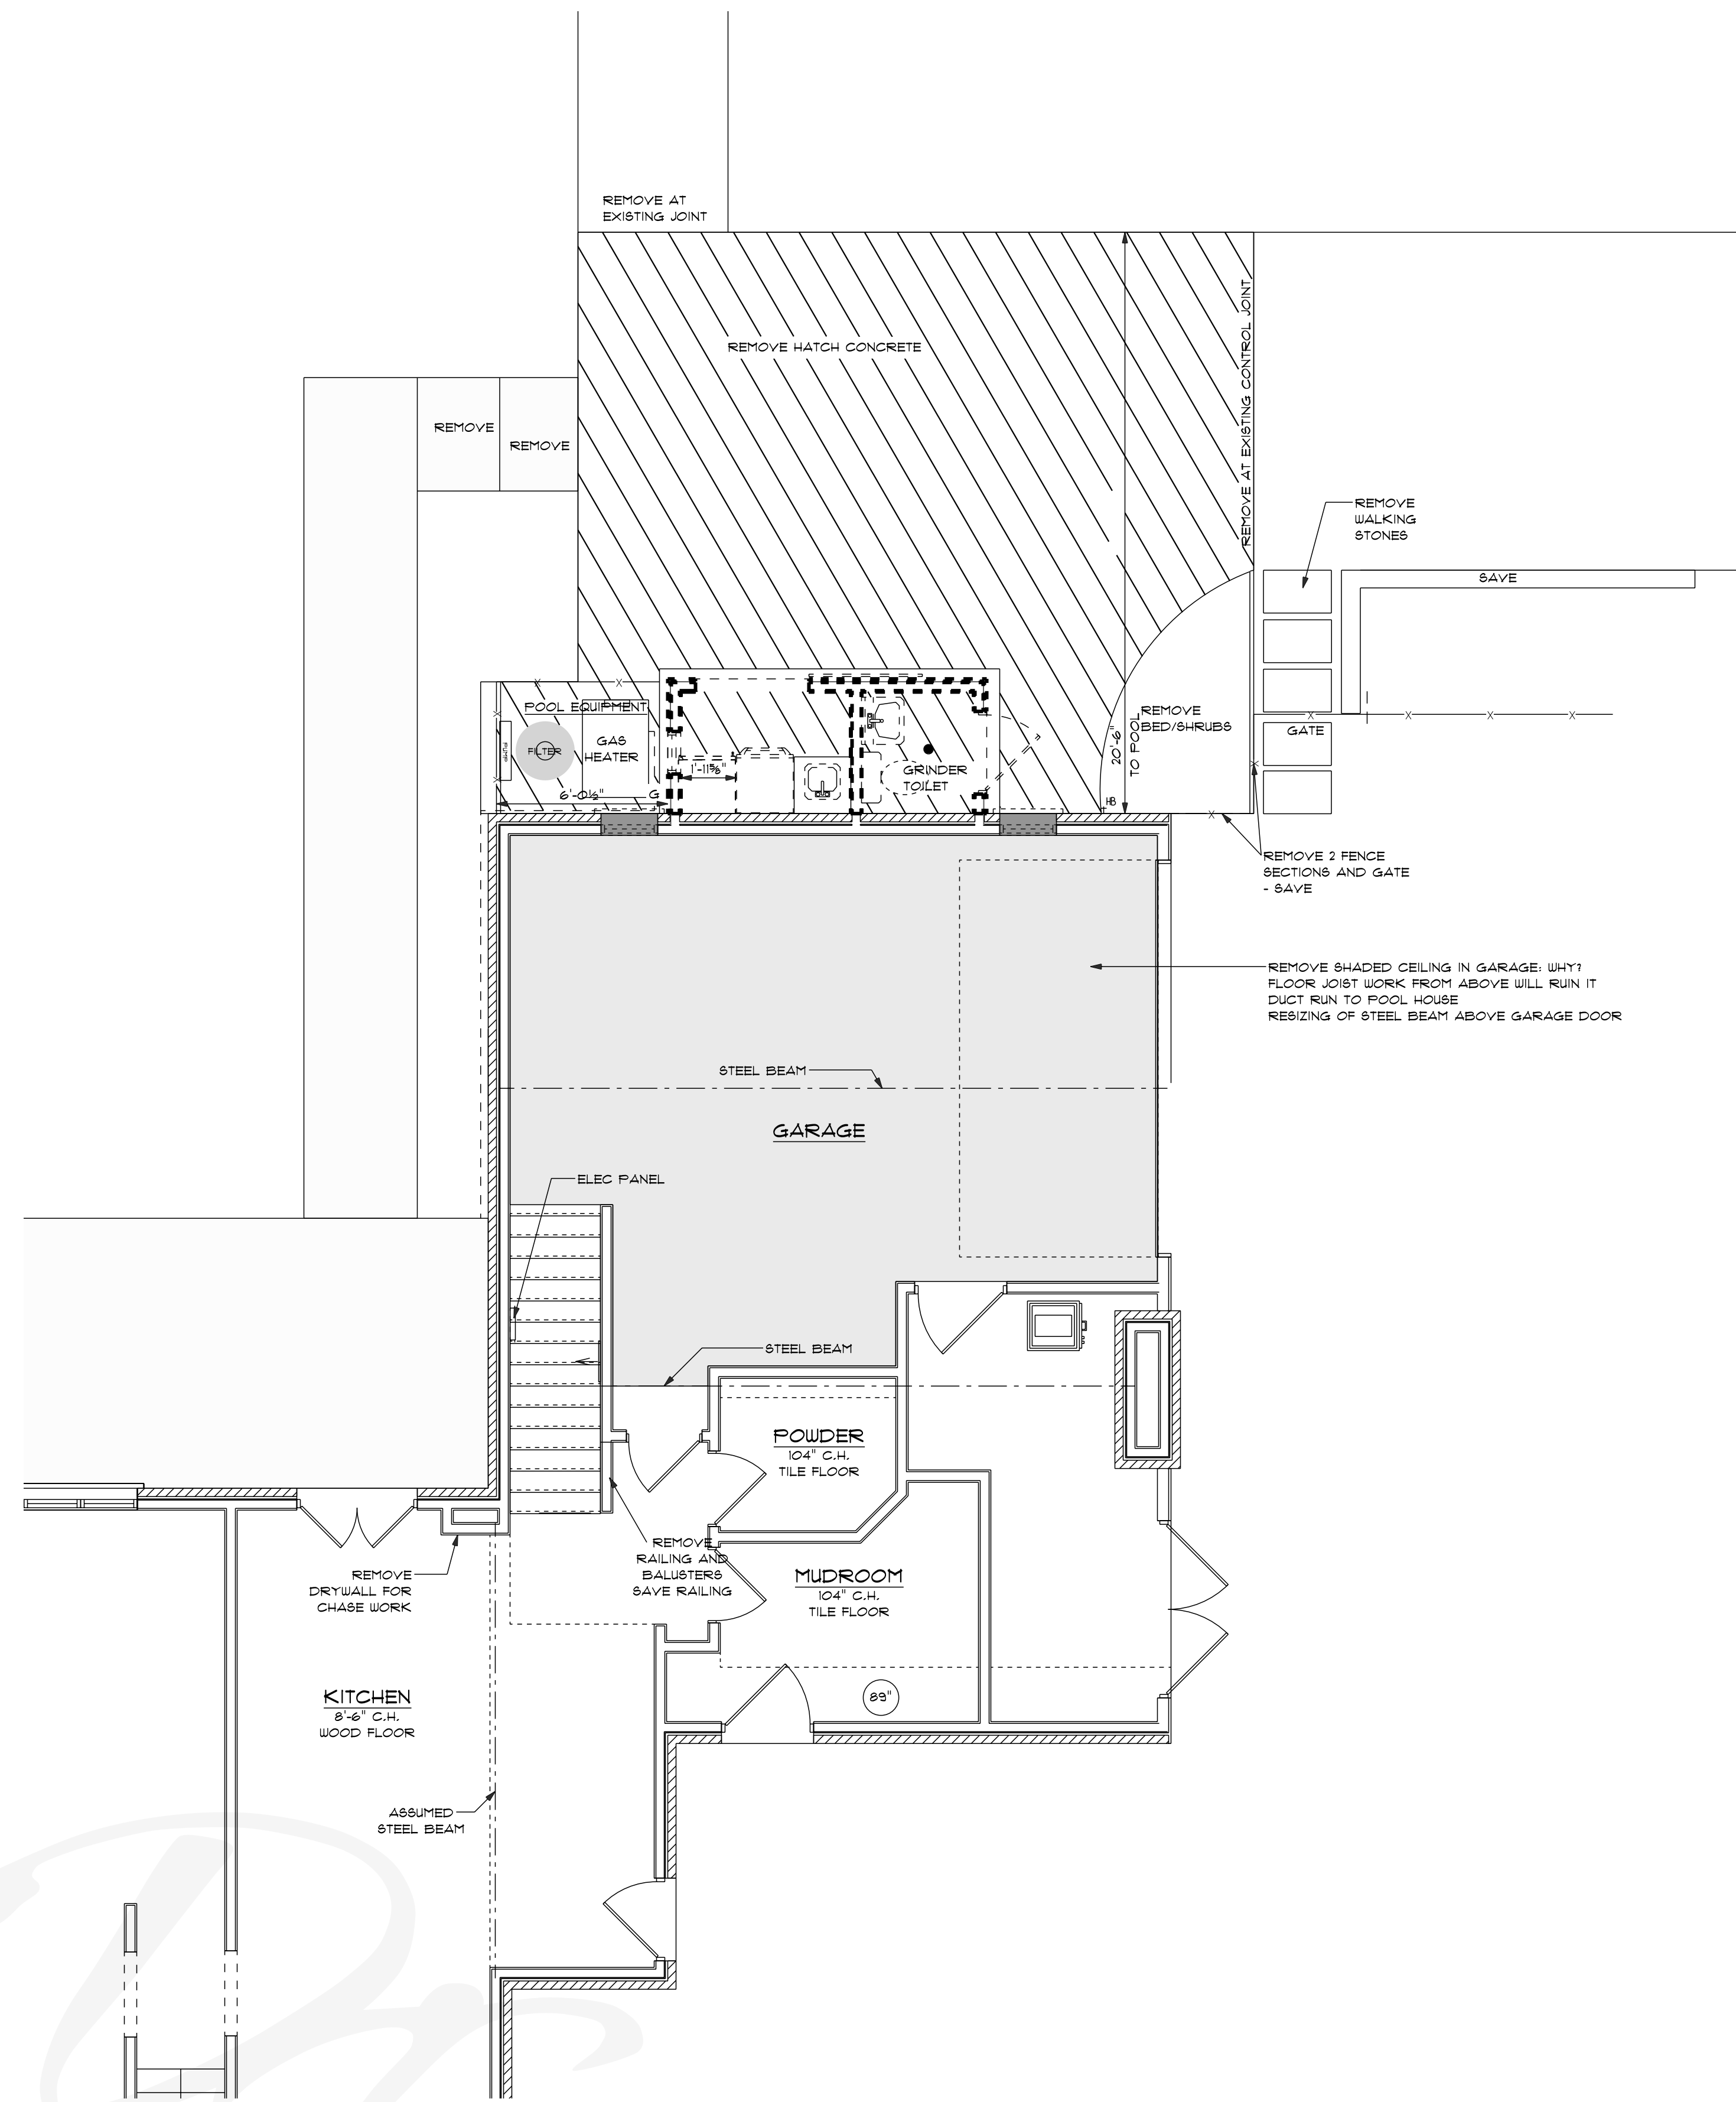

EXISTING FIRST FLOOR PLAN

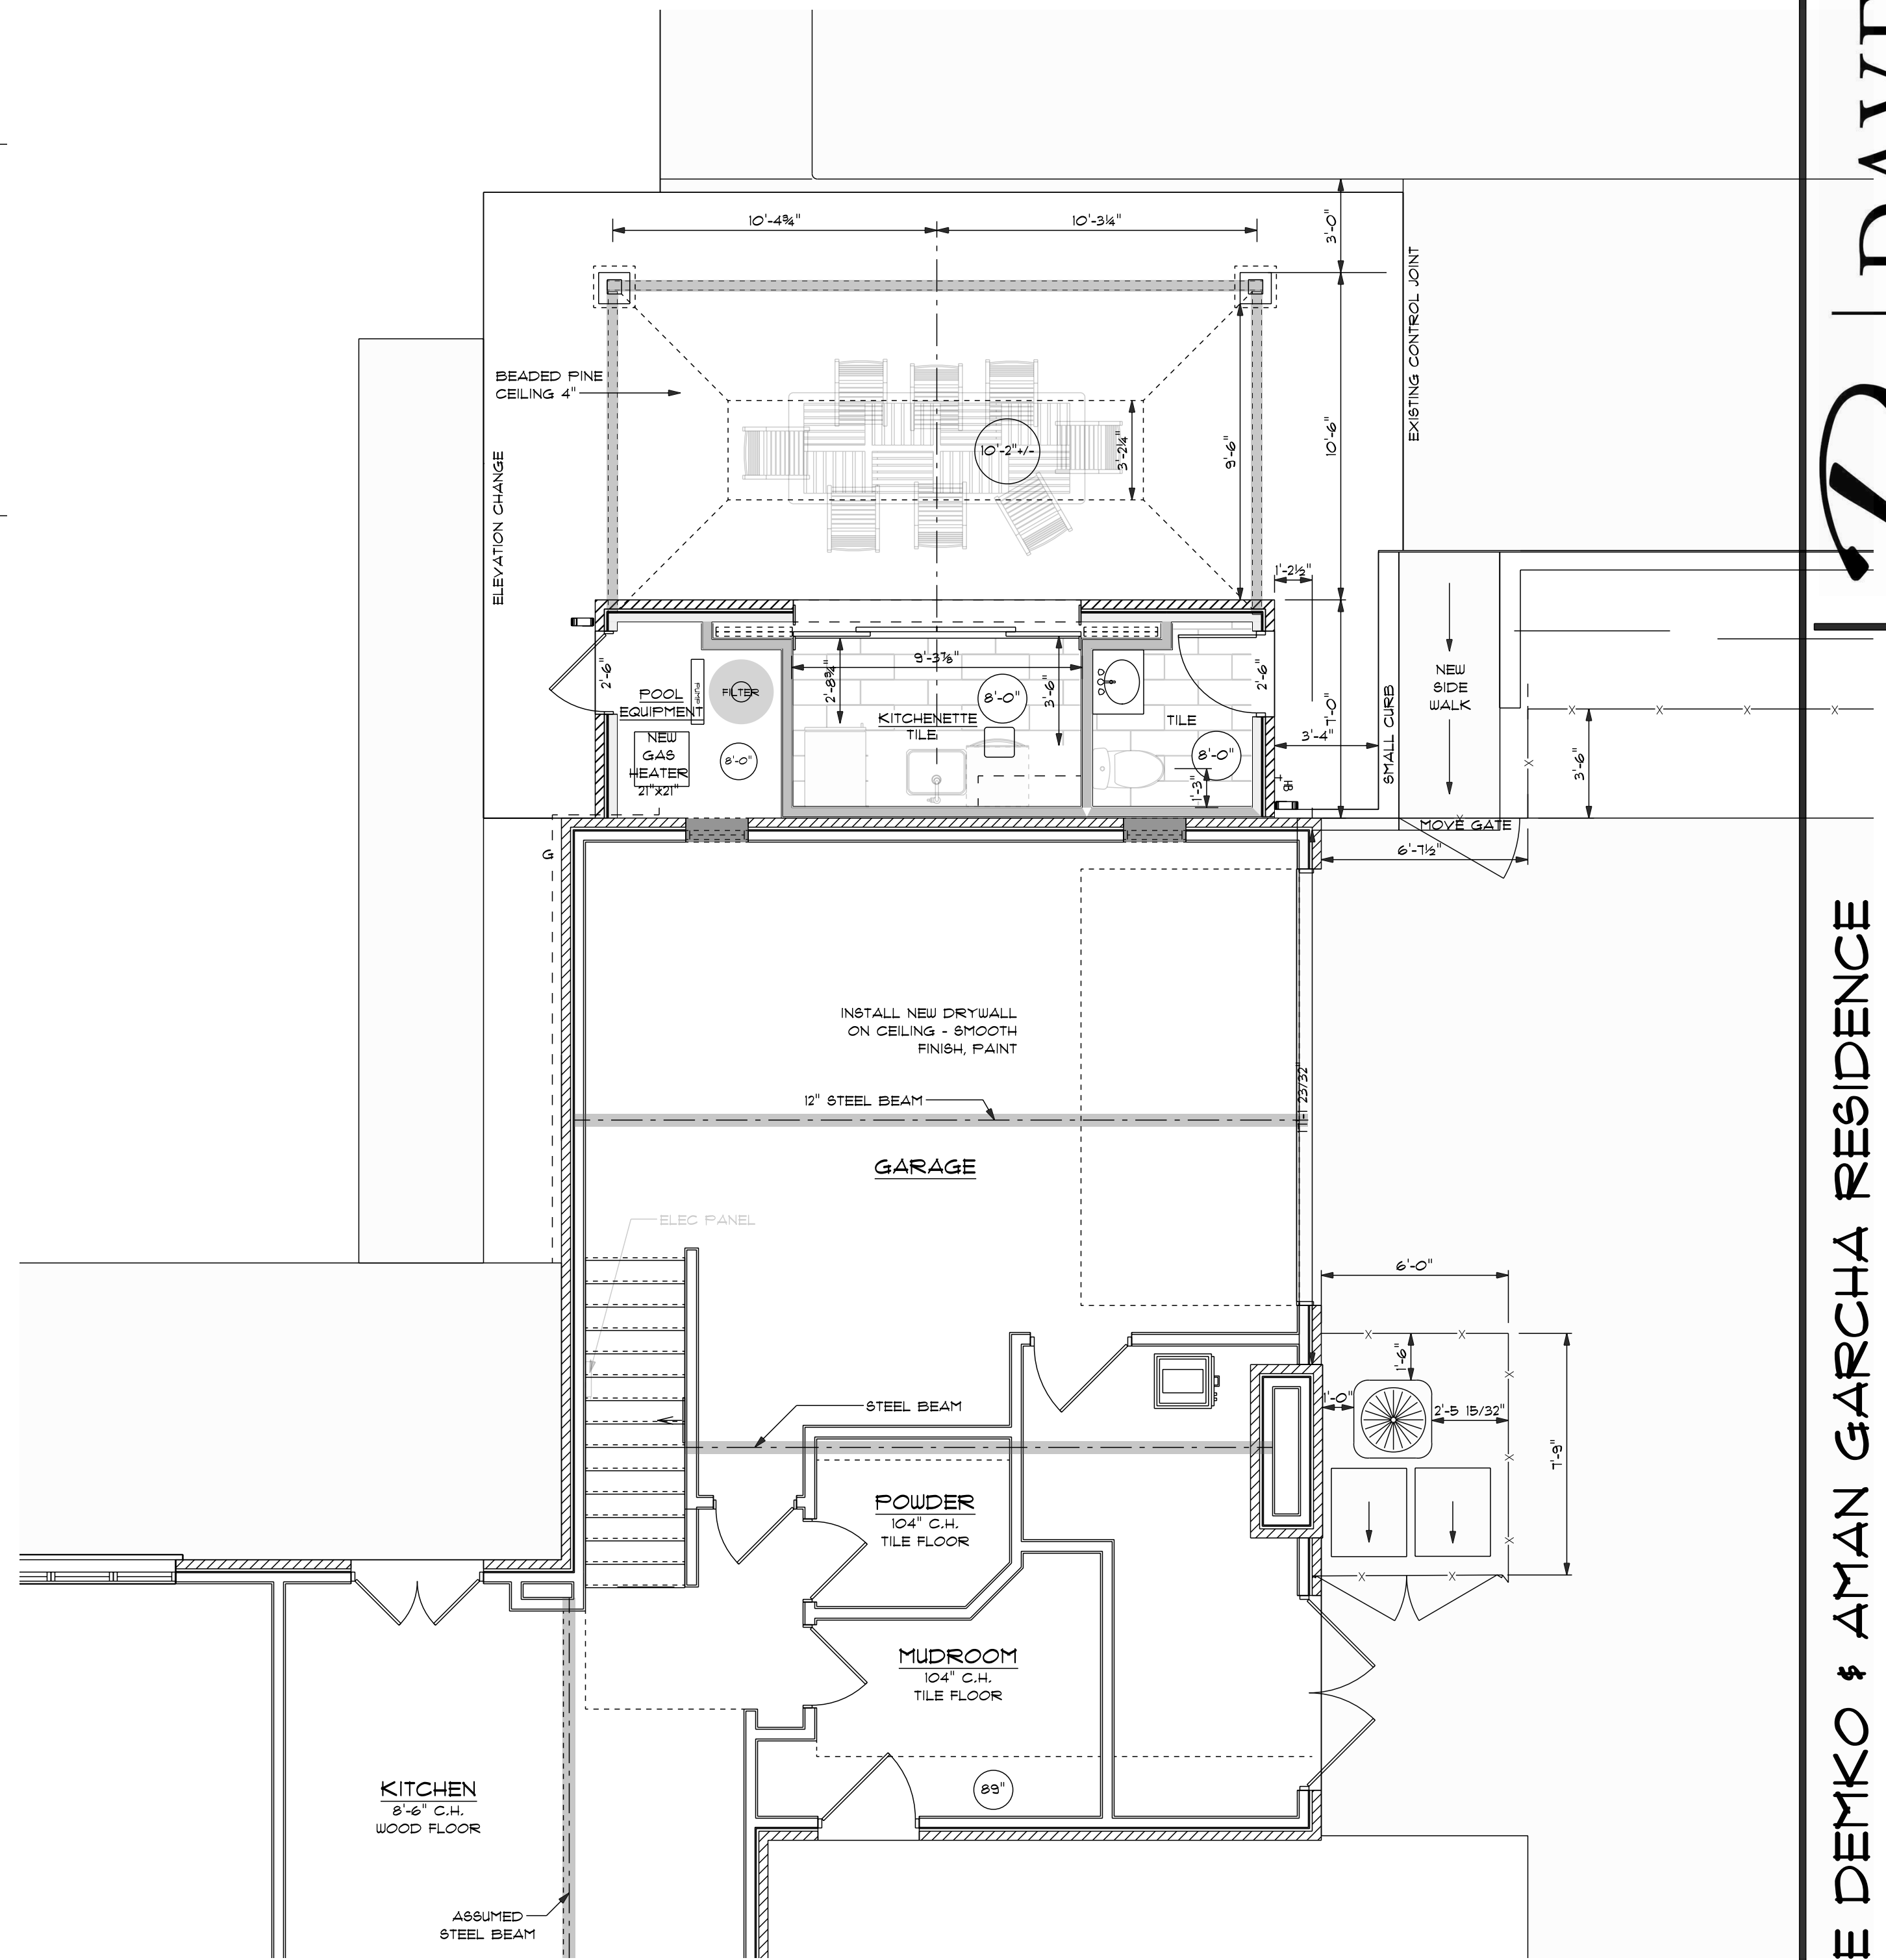

NEW 1ST FLOOR PLAN

COORDINATE ALL FRAMING, CABINET LAYOUTS & FINAL FINISHES w/ DFR ID & DC PRIOR TO INSTALLATION

FIELD VERIFY ALL EXISTING CONDITIONS & DIMENSIONS PRIOR TO CONSTRUCTION ANY VARIATIONS SHOULD BE REPORTED TO THE PM & DC

REVISION	DATE	DESCRIPTION

DESIGNED BY: JENNIFER ZIFFEL  
 ID BY: FAITH HERRING  
 PM BY: T.B.D.  
 PROJ. # 2200000  
 DATE 00.00.22  
 AS-BUILT/NEW  
 SHEET #  
 1 of 2

DANIELLE DEMKO & AMAN GARCHA RESIDENCE  
 125 ASHBOURNE RD, BEXLEY, OH 43209

Approved by:  
 Only use or modifications of these plans without express permission of DFR is strictly prohibited. Mechanical plans to be verified by licensed contractor.

**DANIELLE DEMKO & AMAN GARCHA RESIDENCE**  
 125 ASHBOURNE RD, BEXLEY, OH 43209


Approved by:  
 JENNIFER ZIFFEL  
 FAITH HERRING  
 T.B.D.

DESIGNED BY:  
 JENNIFER ZIFFEL  
 ID BY:  
 FAITH HERRING  
 PM BY:  
 T.B.D.


PROJ. # 2200000  
 DATE 00.00.22

**AS-BUILT/NEW**

SHEET #  
 1 of 2

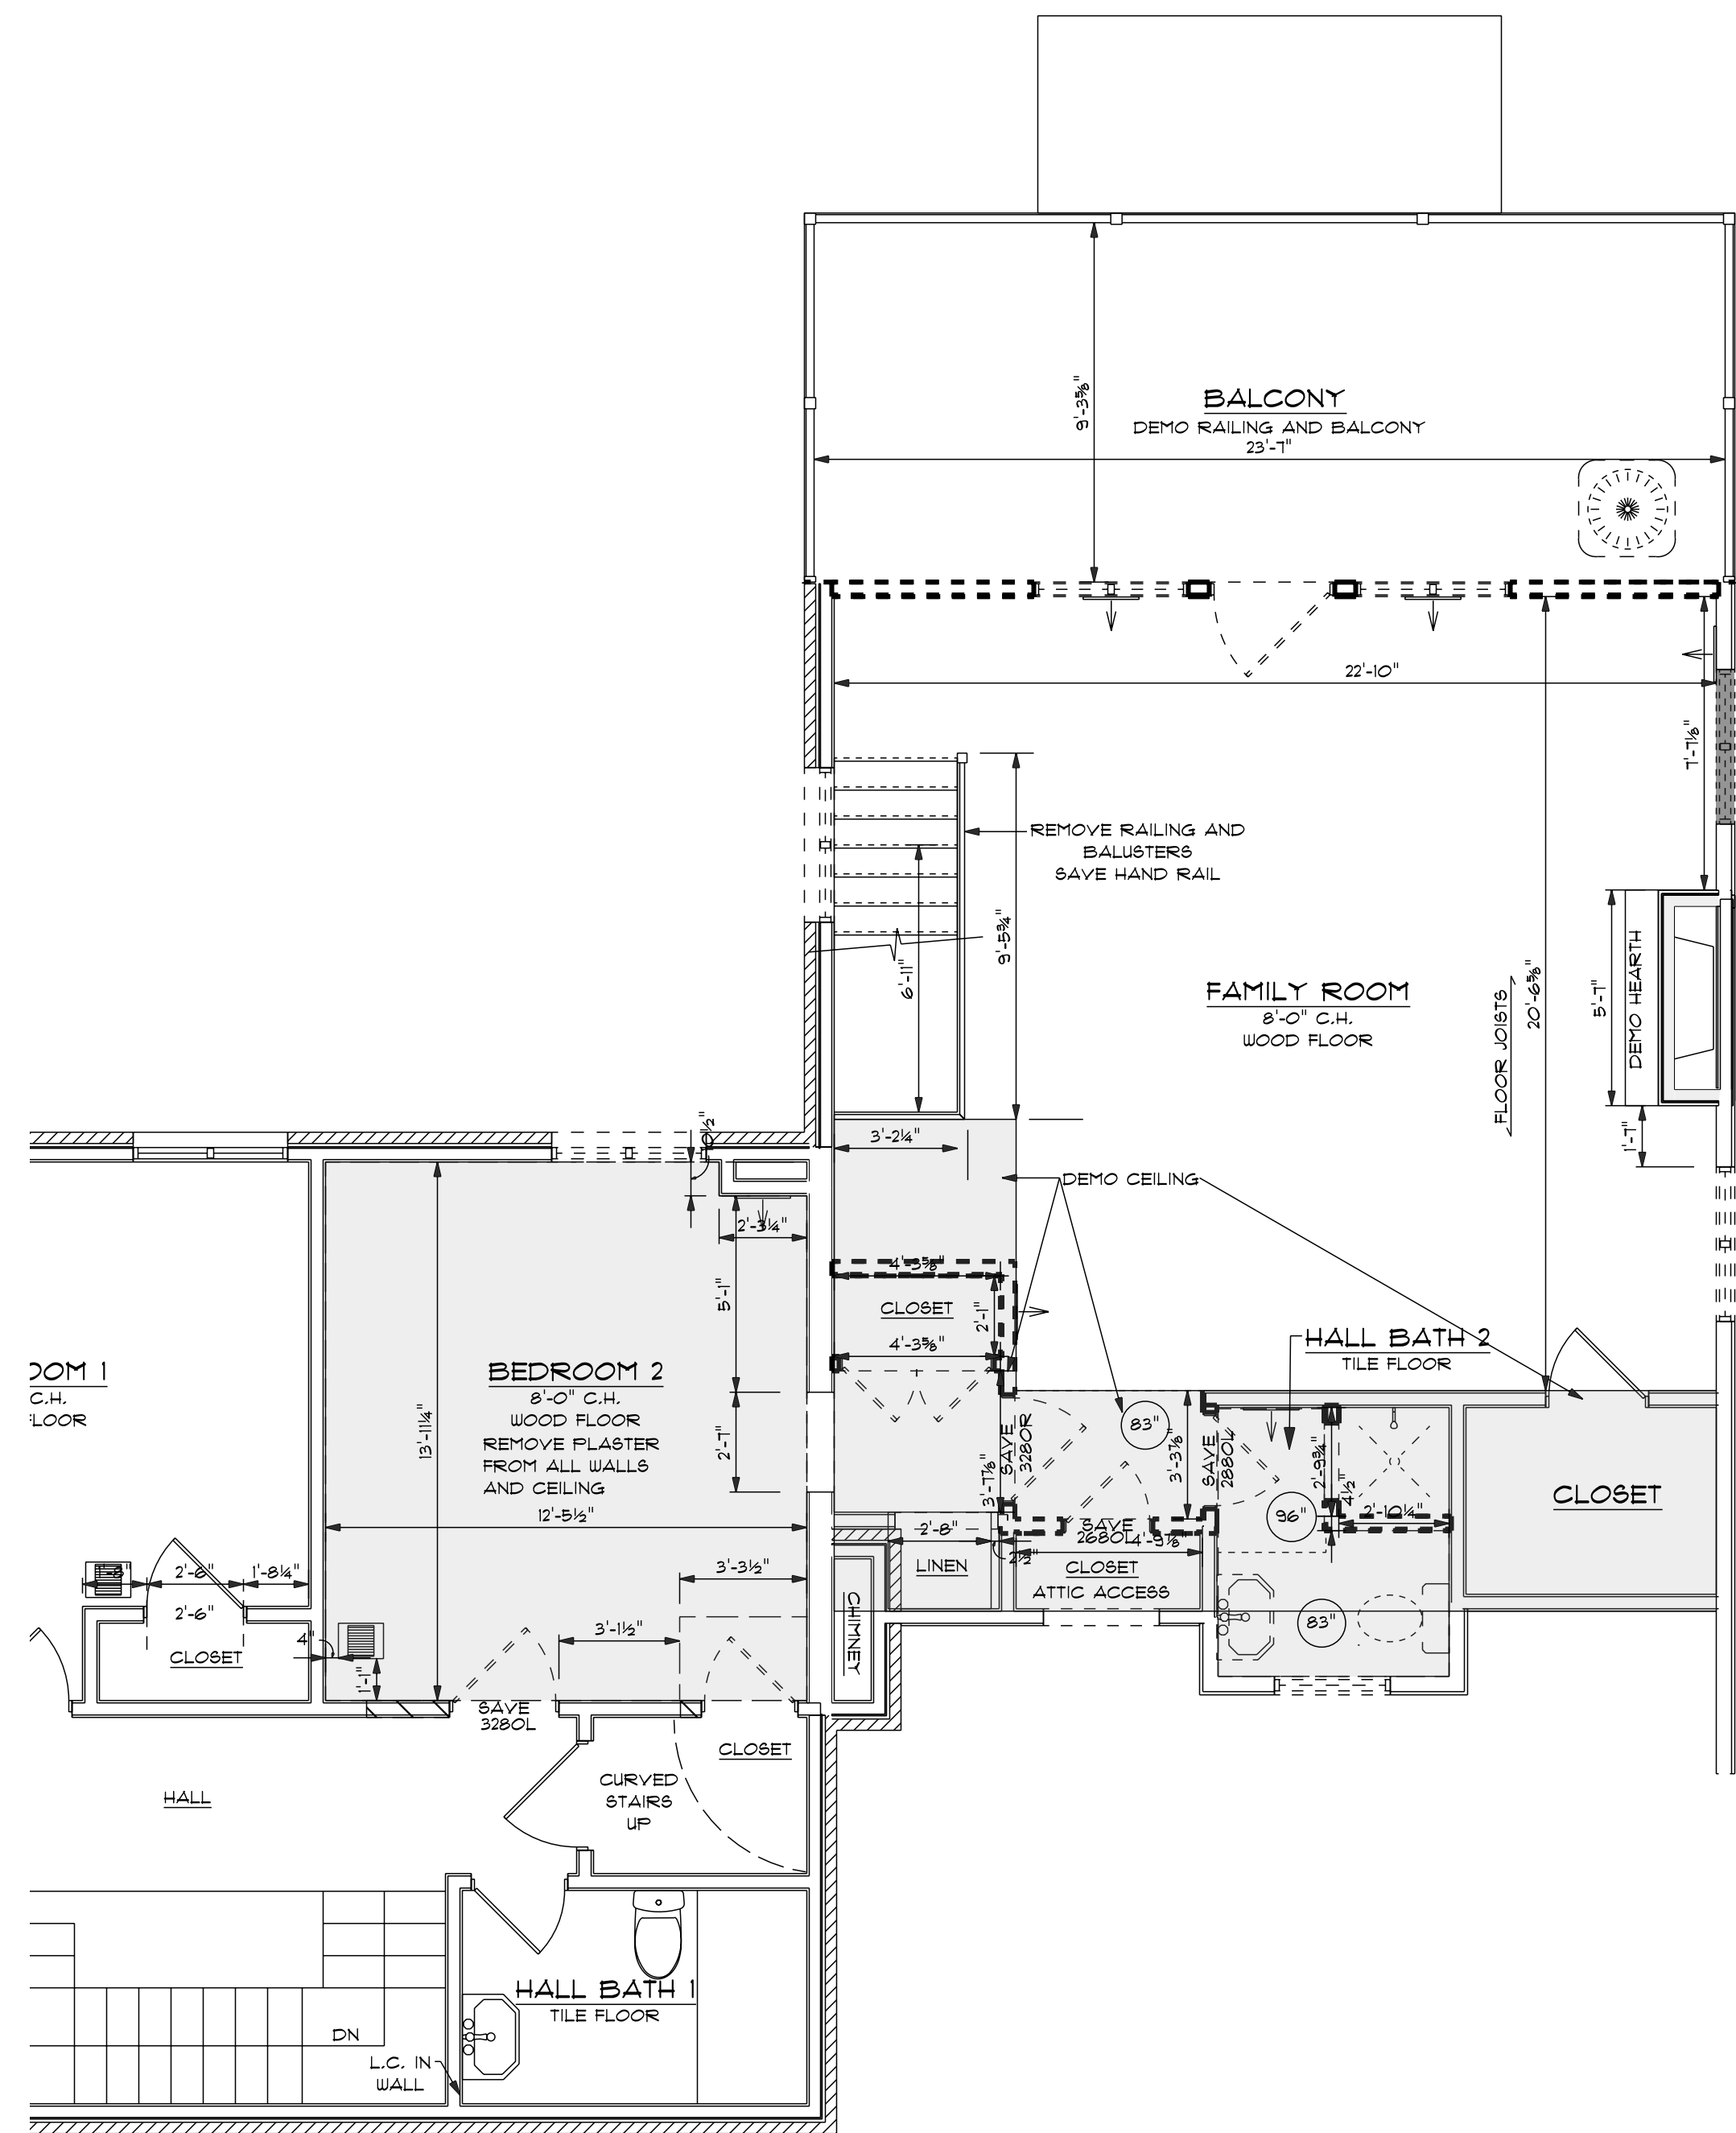

**EXISTING 2ND FLOOR PLAN**

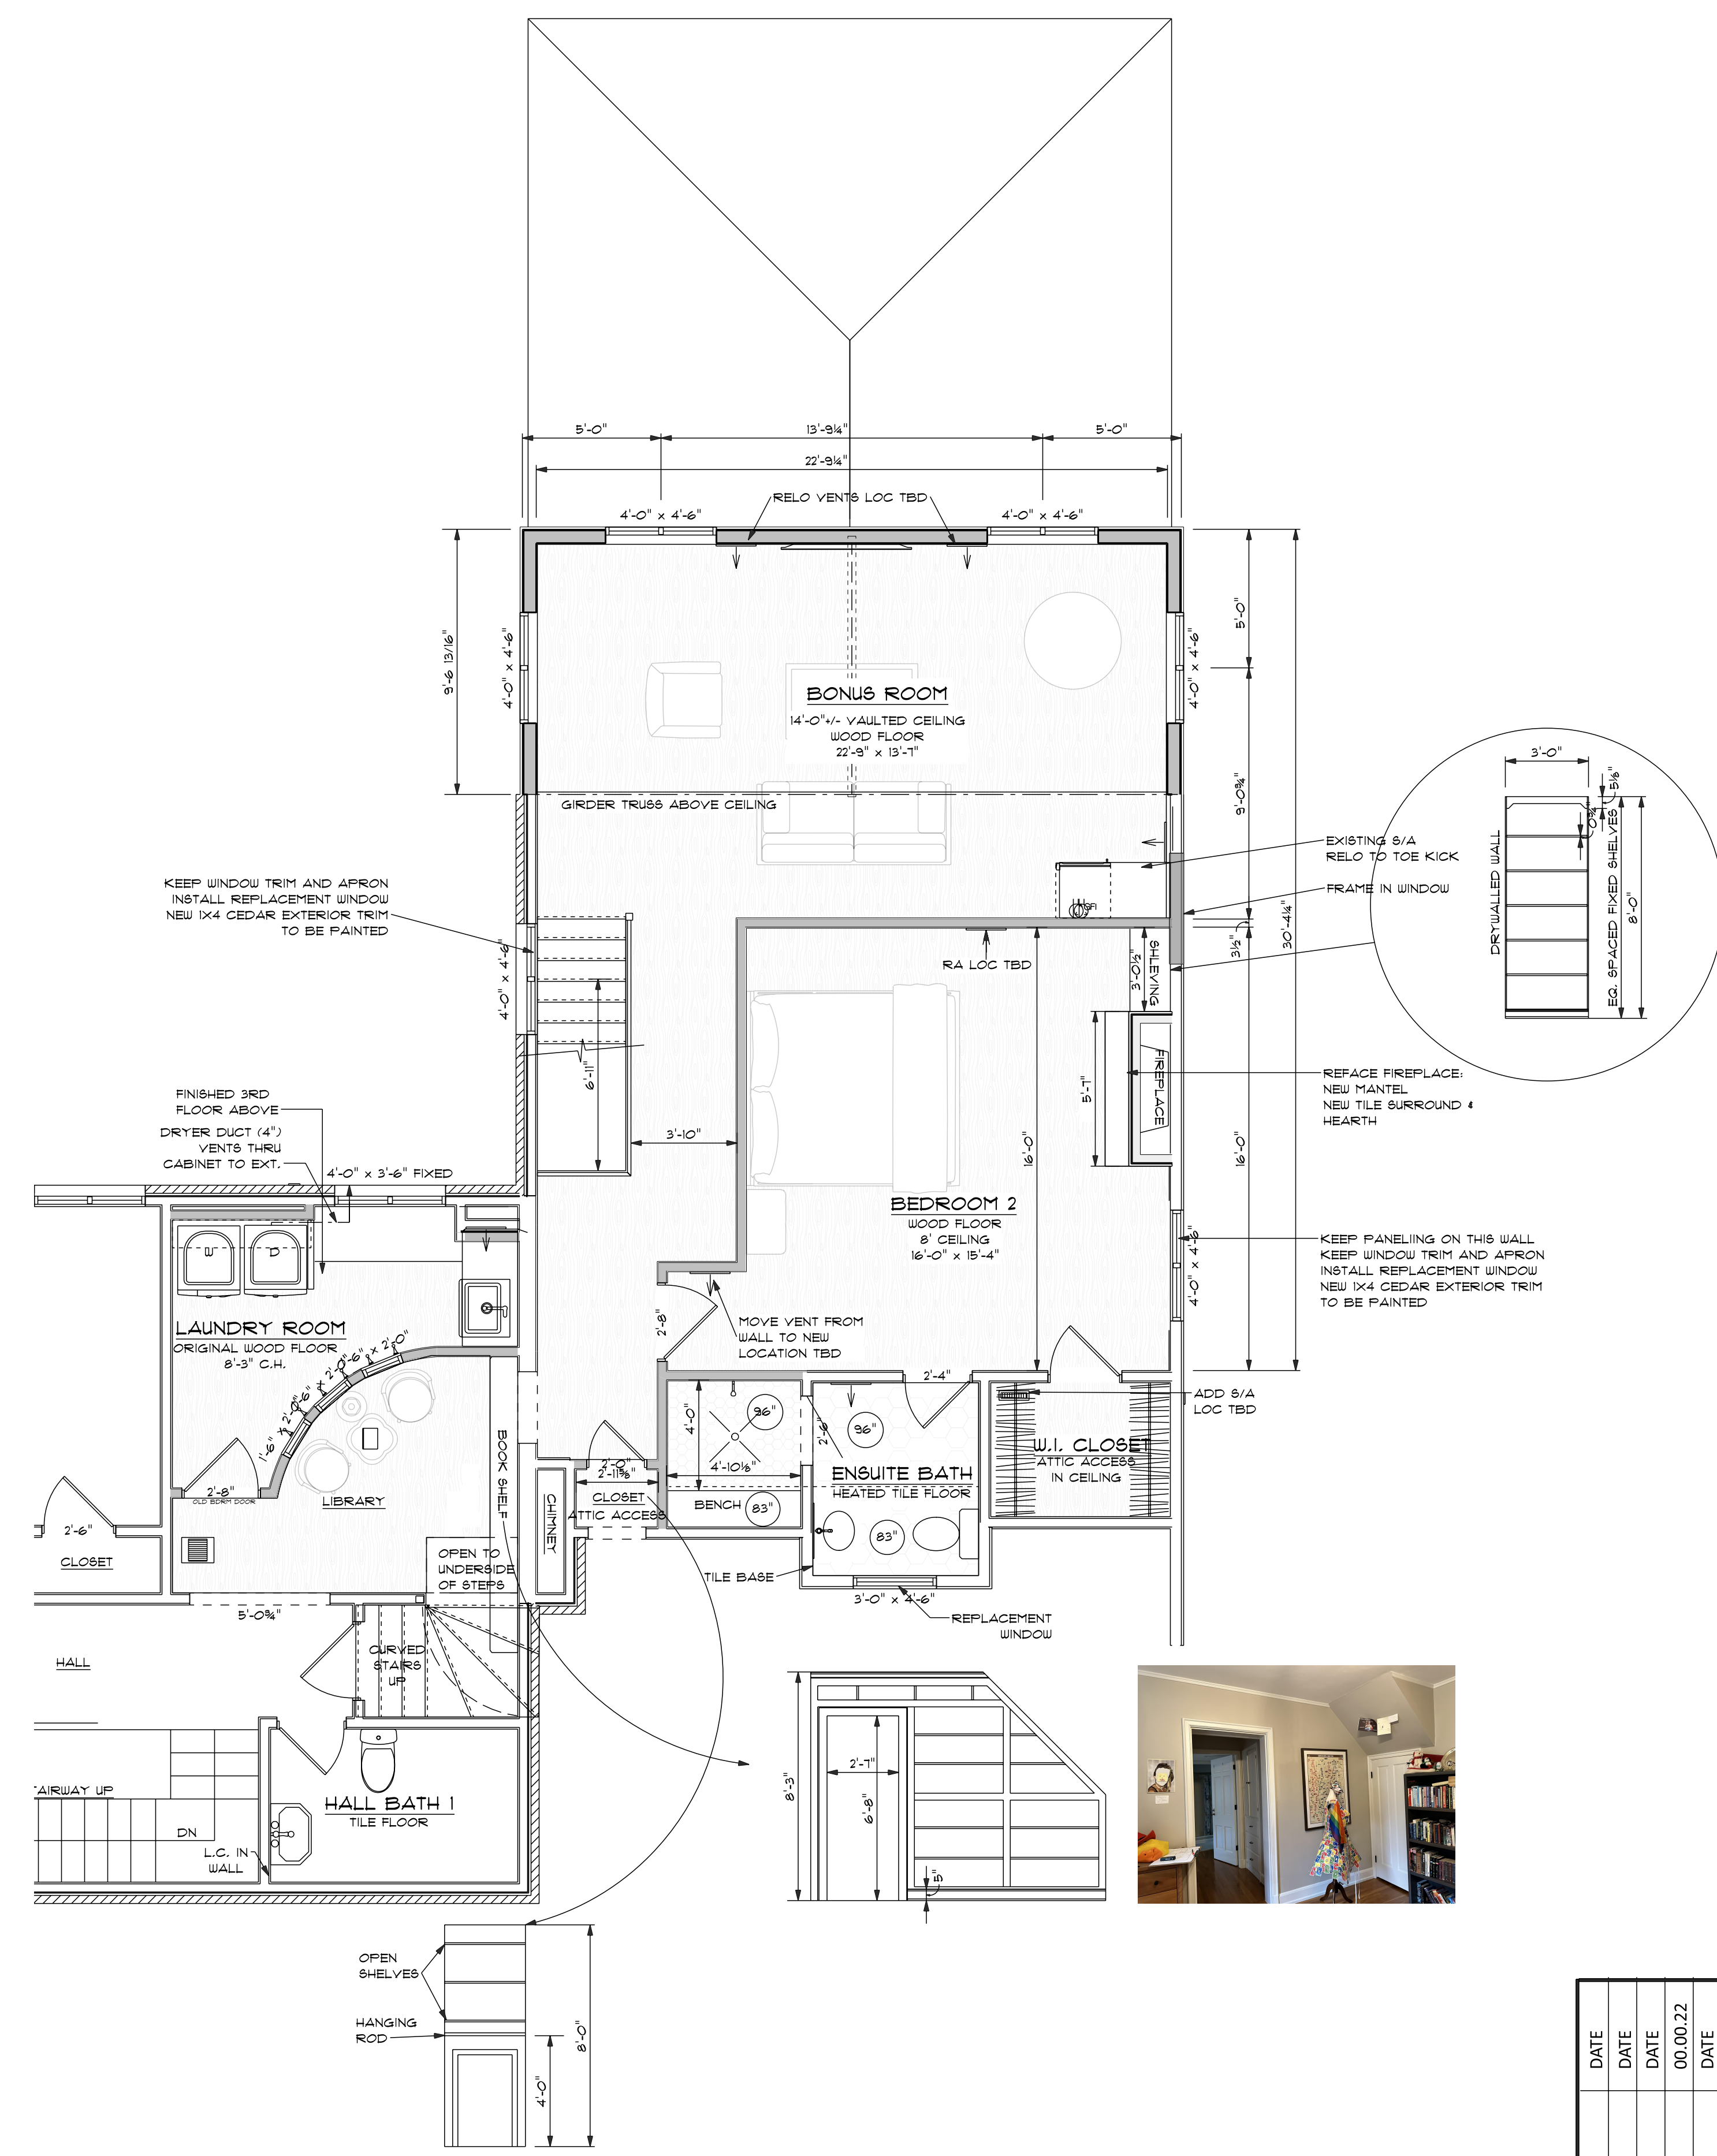

**NEW 2ND FLOOR PLAN**



COORDINATE ALL FRAMING, CABINET LAYOUTS & FINAL FINISHES w/ DFR ID & DC PRIOR TO INSTALLATION

FIELD VERIFY ALL EXISTING CONDITIONS & DIMENSIONS PRIOR TO CONSTRUCTION ANY VARIATIONS SHOULD BE REPORTED TO THE PM & DC


Scale: 1/4" = 1' (unless otherwise noted)

REVISION	DATE	DESCRIPTION



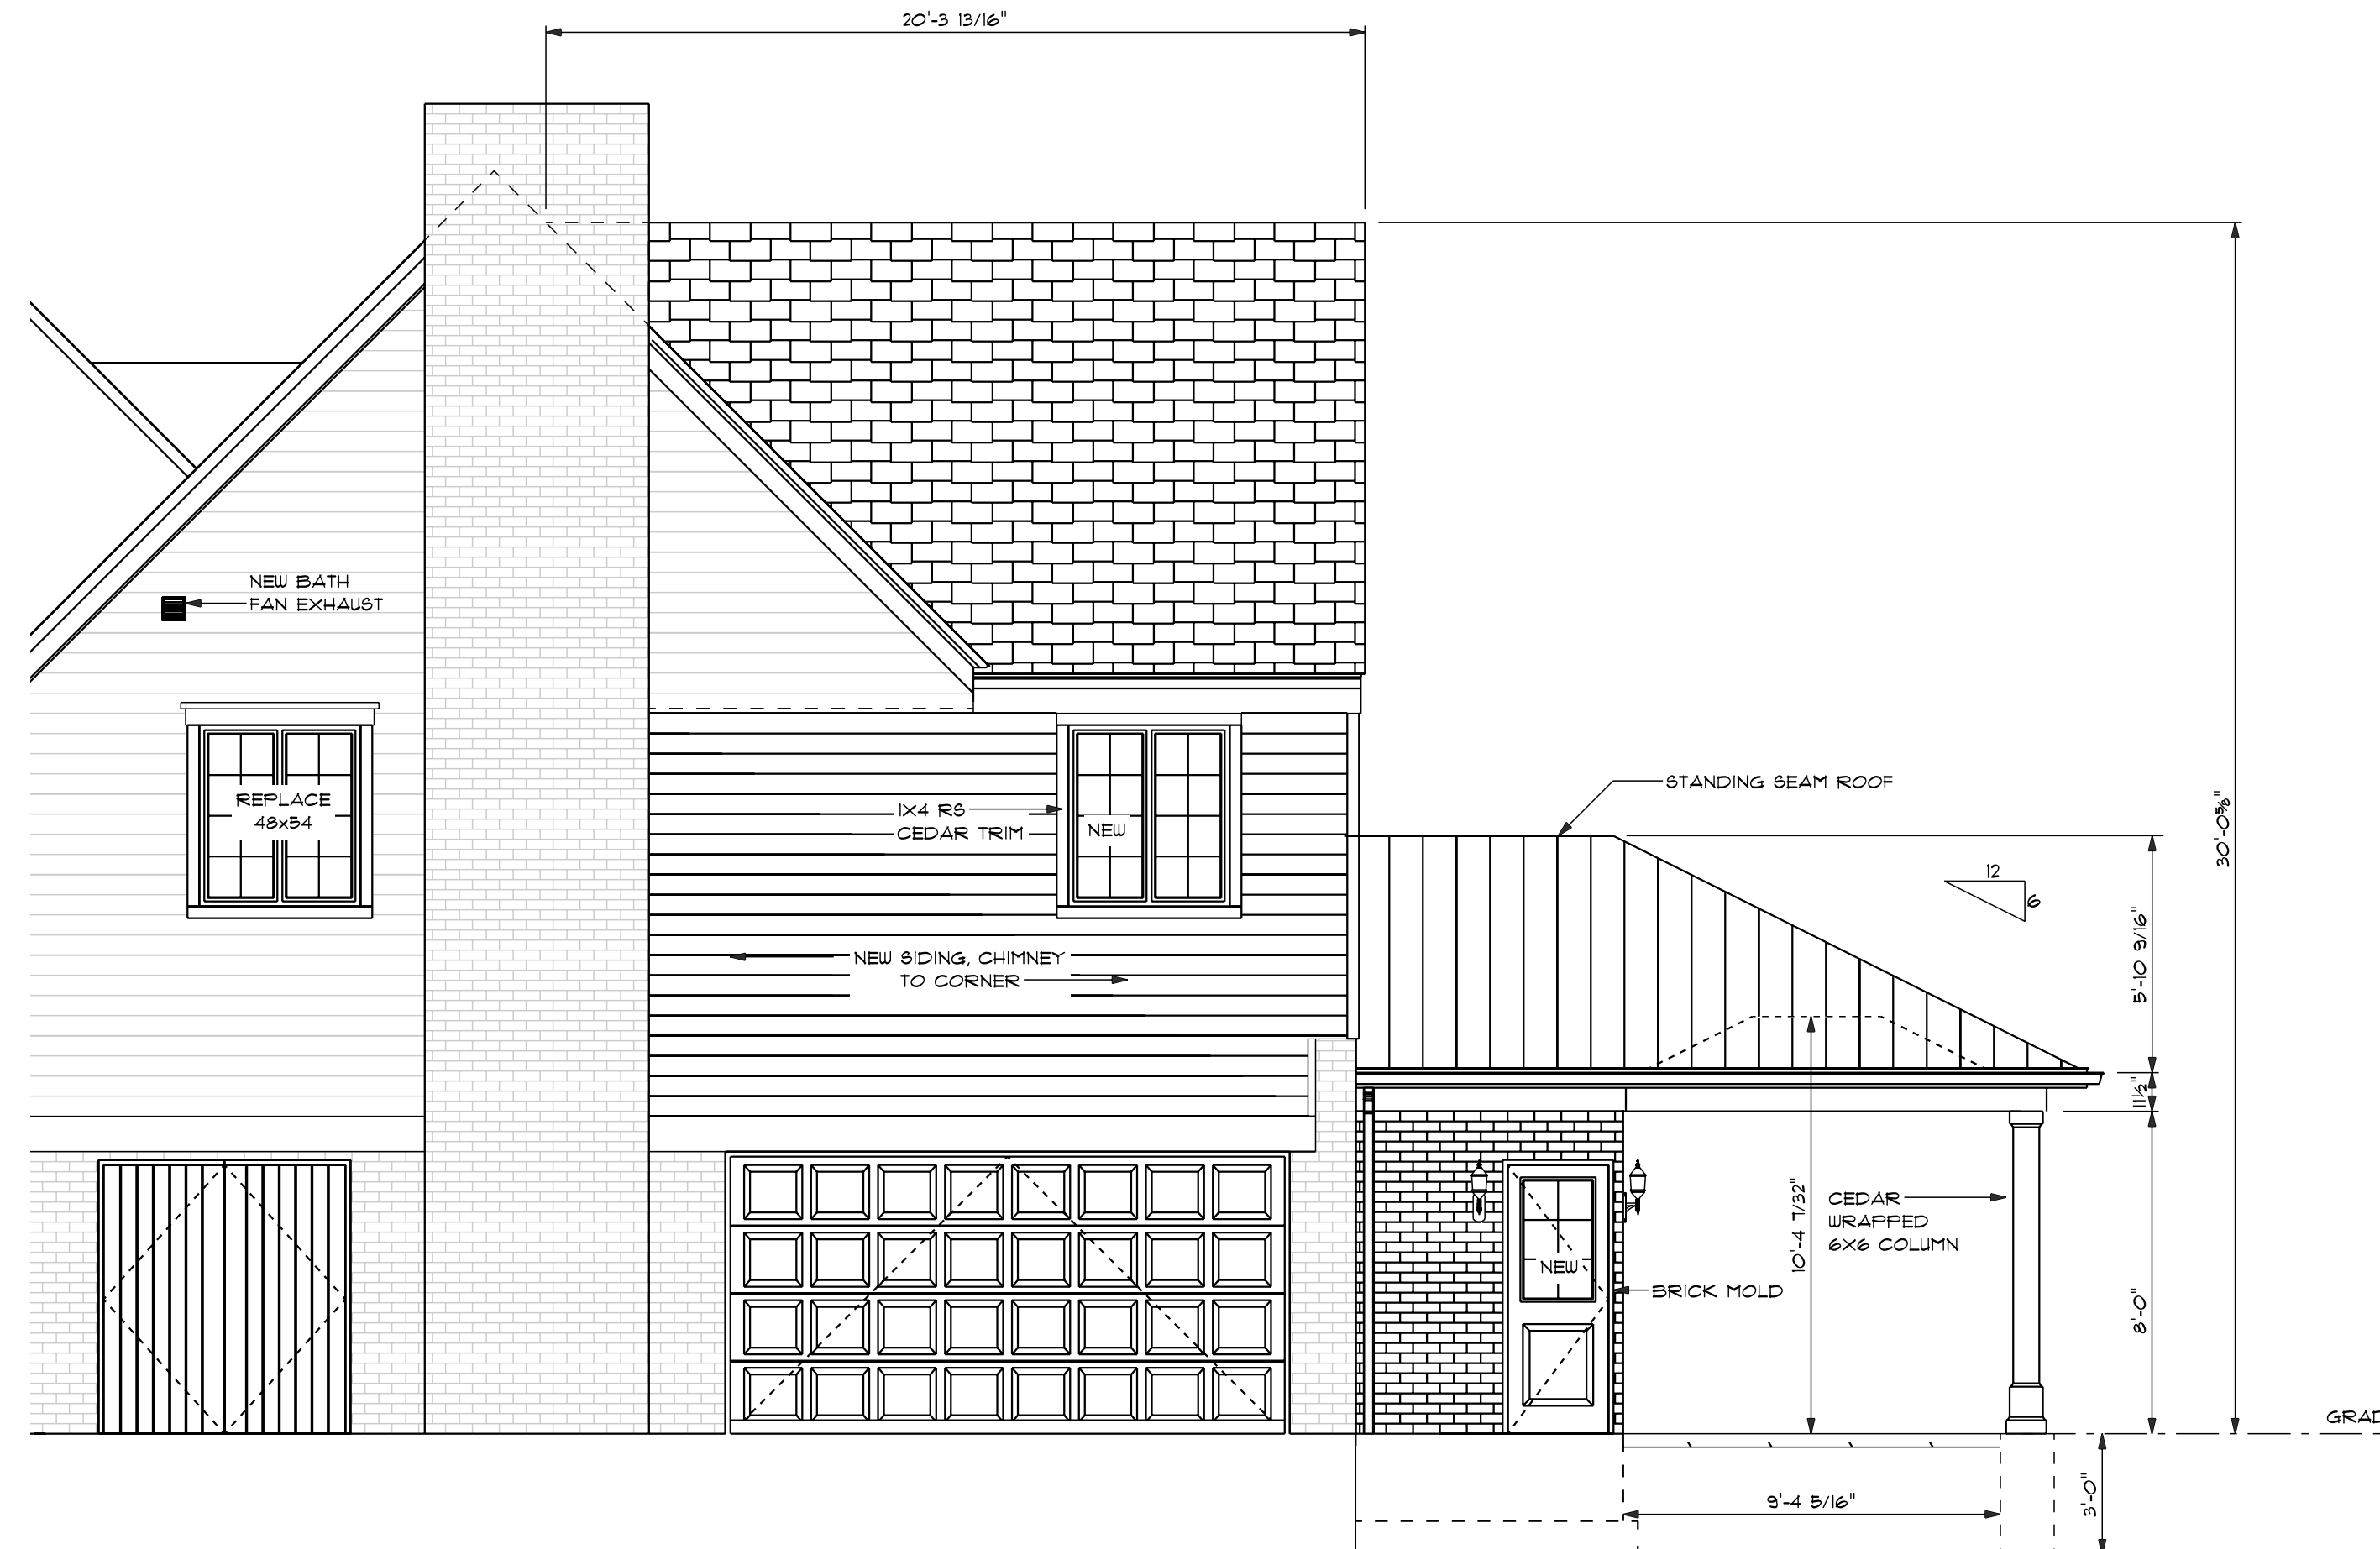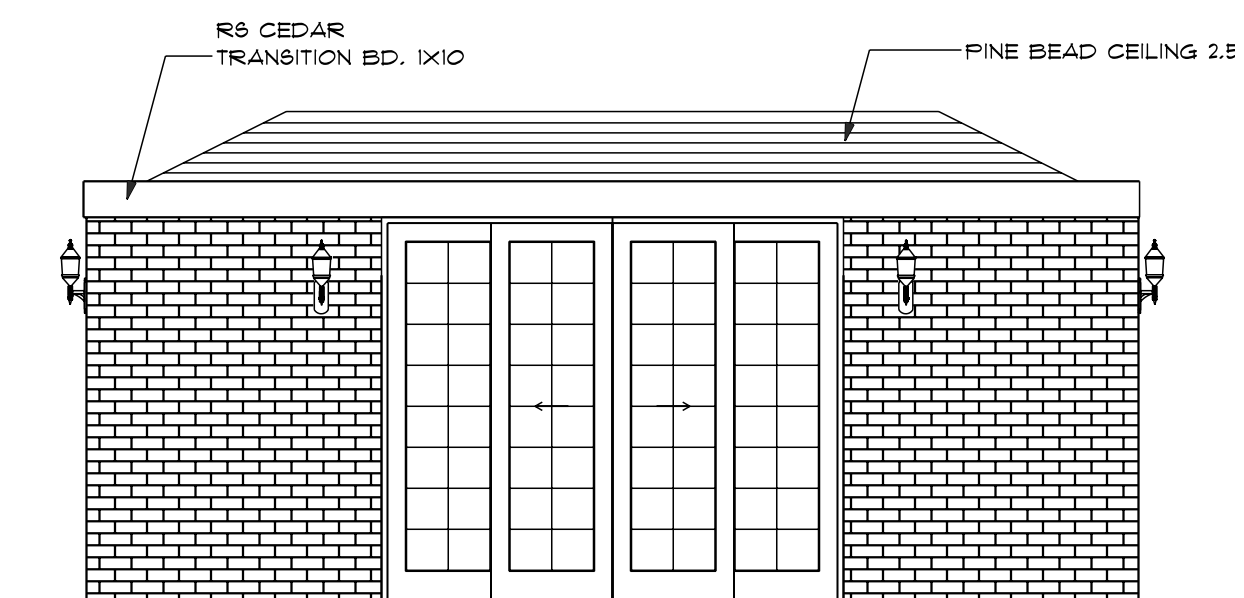

EXISTING 2ND FLOOR PLAN

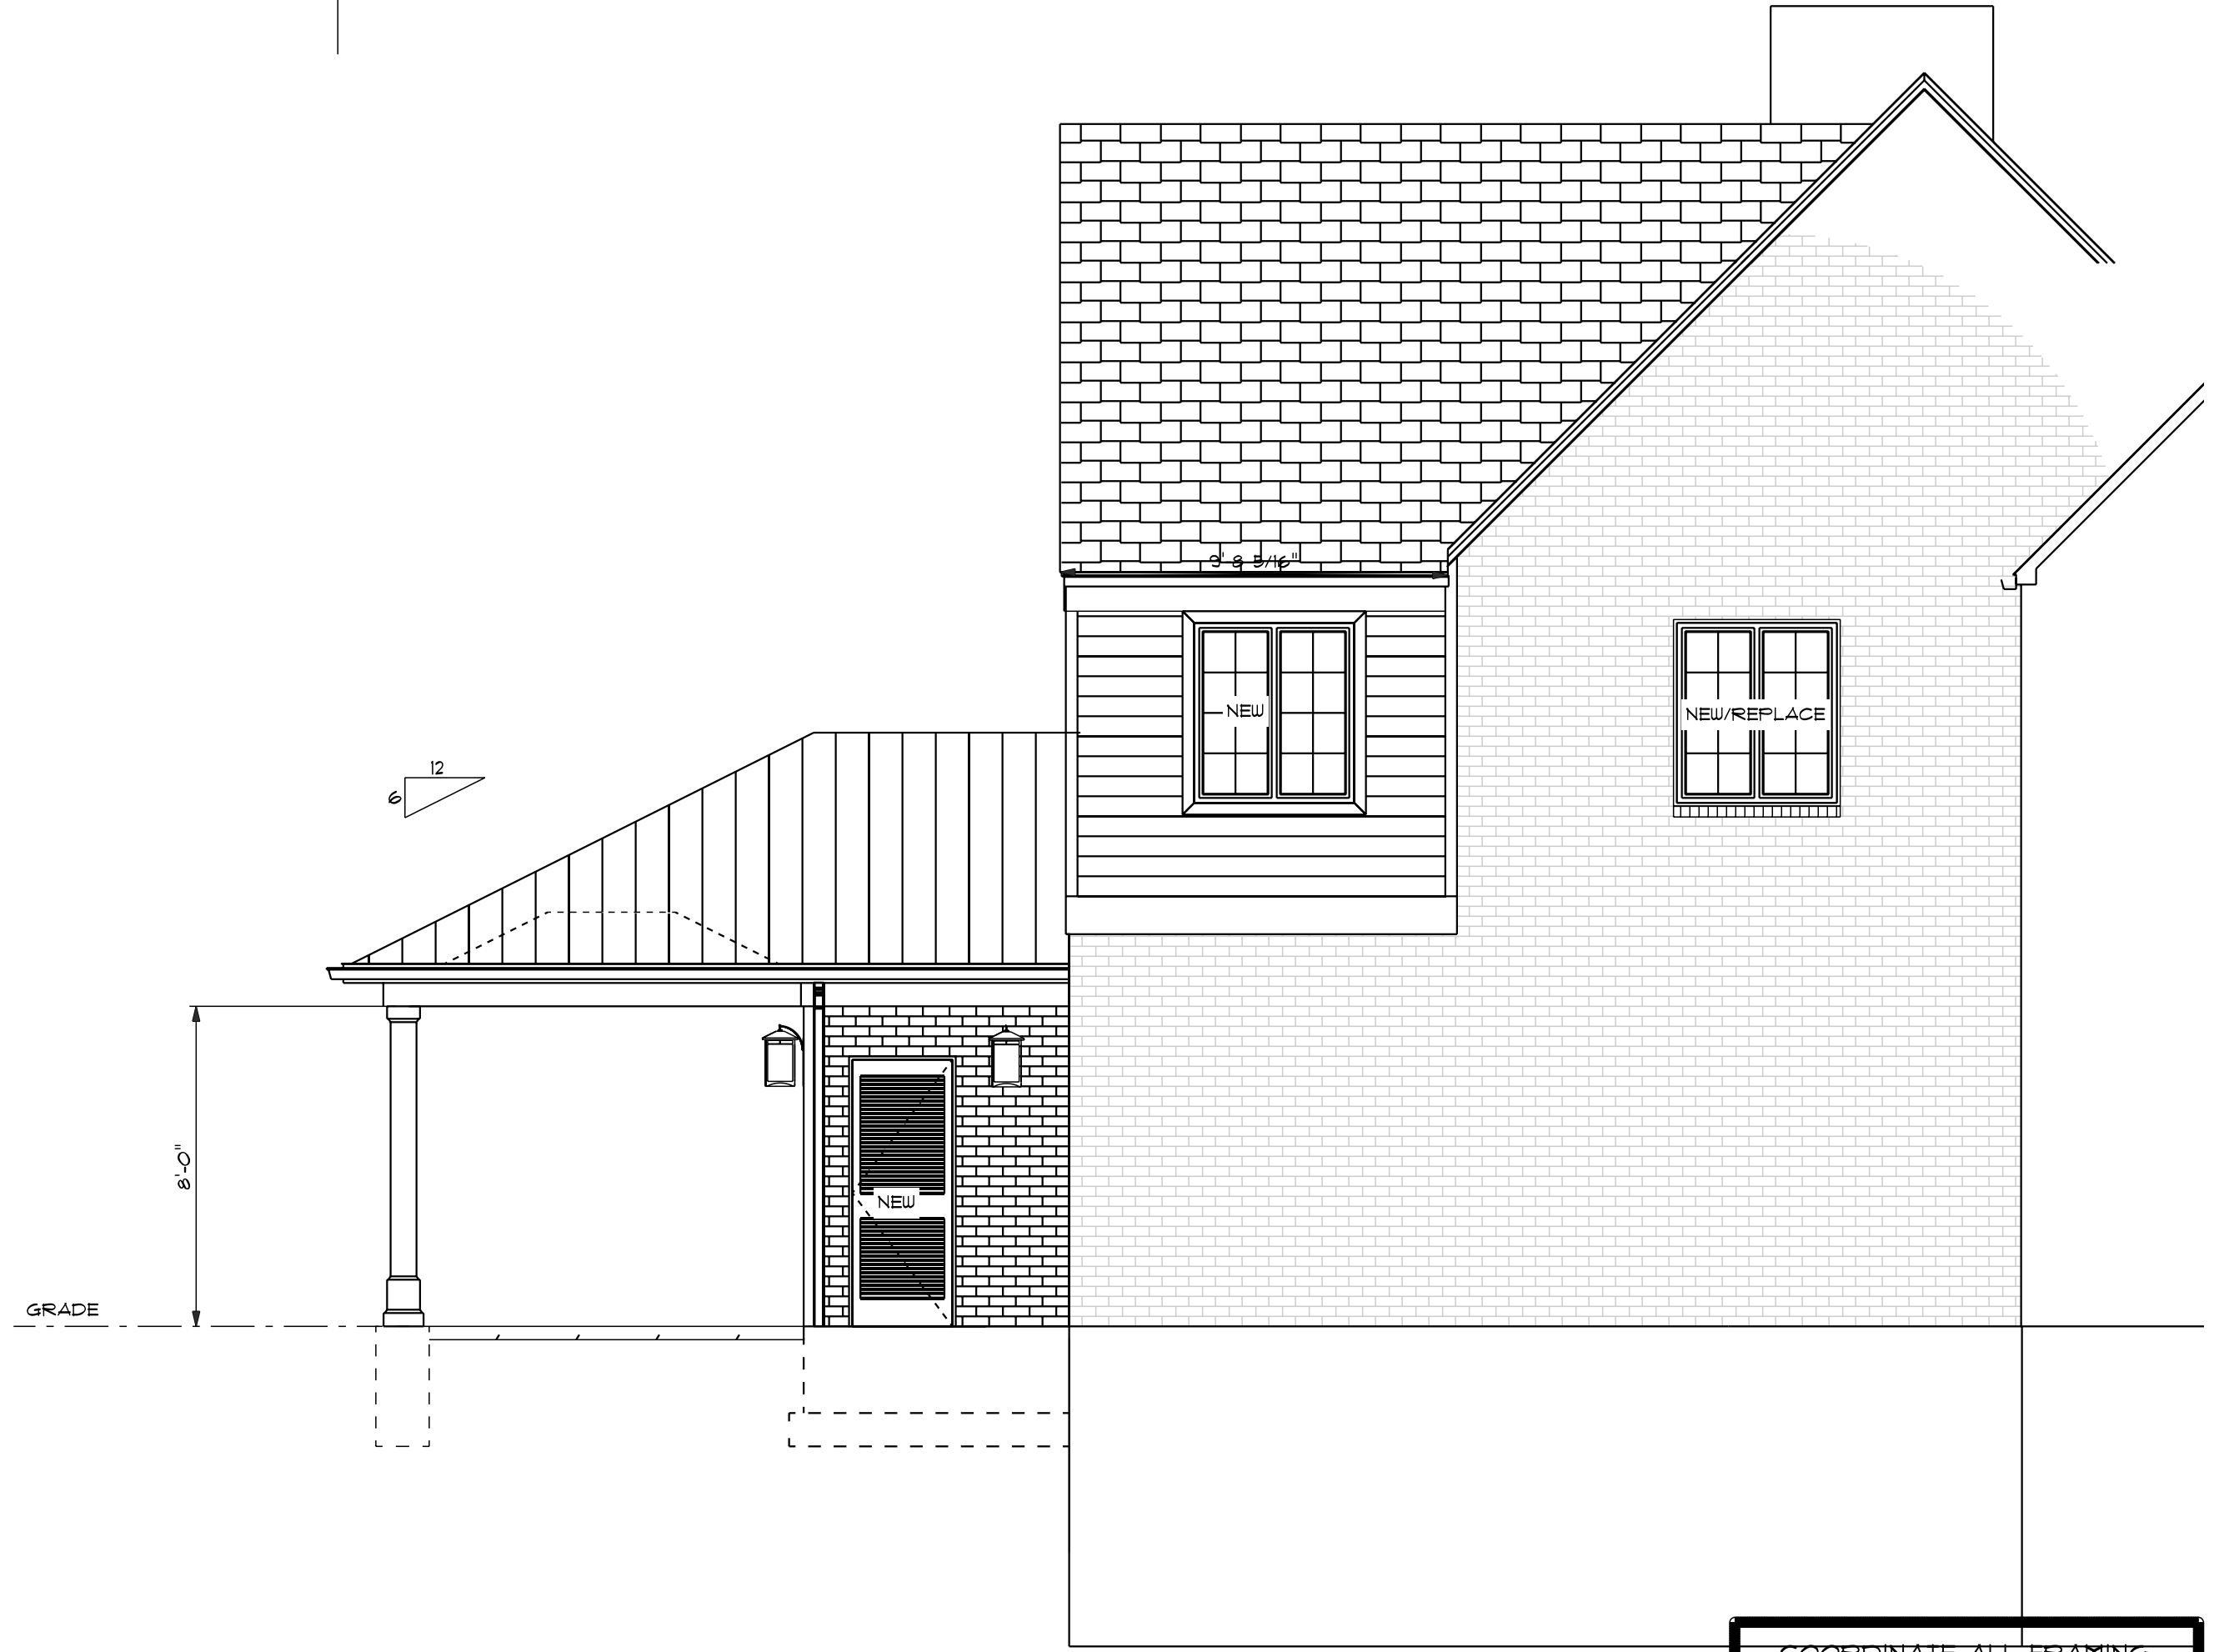

NEW 2ND FLOOR PLAN

COORDINATE ALL FRAMING, CABINET LAYOUTS & FINAL FINISHES w/ DFR ID & DC PRIOR TO INSTALLATION

FIELD VERIFY ALL EXISTING CONDITIONS & DIMENSIONS PRIOR TO CONSTRUCTION ANY VARIATIONS SHOULD BE REPORTED TO THE PM & DC

REVISION	DATE	DESCRIPTION

DESIGNED BY: JENNIFER ZIFFEL  
 ID BY: FAITH HERRING  
 PM BY: T.B.D.  
 PROJ. # 2200000  
 DATE 00.00.22  
 ELEVATIONS  
 SHEET #  
 1 of 2

DANIELLE DEMKO & AMAN GARCHA RESIDENCE  
 125 ASHBOURNE RD, BEXLEY, OH 43209

DAVE FOX  
 DESIGN • BUILD • REMODELERS  
 3505 W. Dublin-Granville Rd, Columbus, OH 43235  
 www.davefox.com 614-459-7211