


All drawings and written material appearing herein constitute the original and unpublished work of the architect and the same may not be duplicated, used, or disclosed without the written consent of the architect. ©

BEXLEY POLICE FACILITY
559 NORTH CASSINGHAM ROAD
BEXLEY, OHIO 43209

08/05/2008
BIDDING DOCUMENTS
CONSTRUCTION DOCUMENTS
ADDENDUM
SITE UTILITY PLAN
PROJECT NO.: BAY06

U100

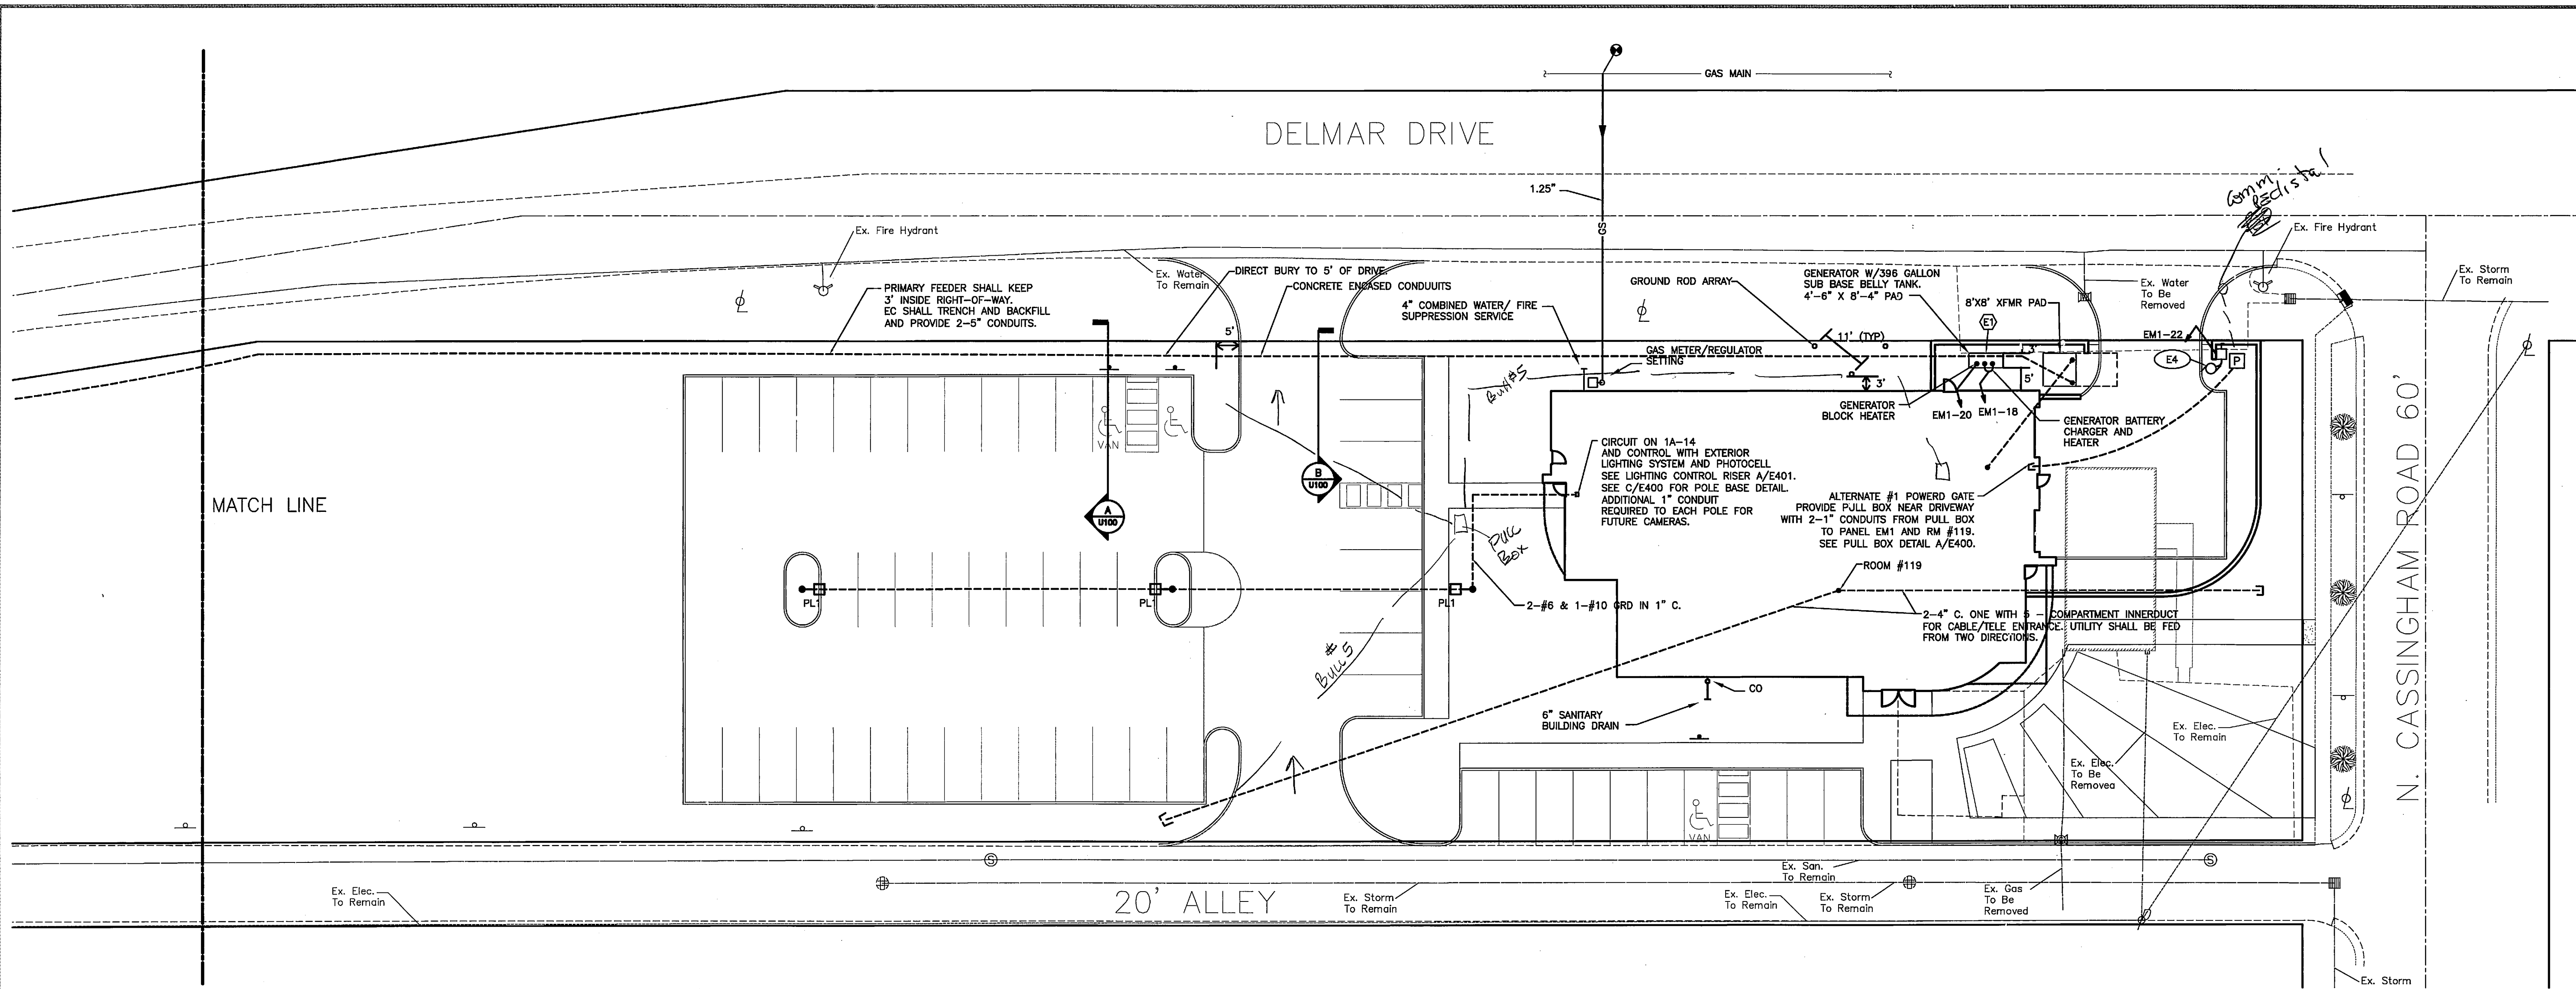

**PROPOSED BEXLEY
POLICE FACILITY
SITE UTILITY PLAN**
SCALE: 1"=40' F.F. 100.00'


NOTES

- E1 GENERATOR TANK MUST NOT EXCEED 36" IN WIDTH TO MAINTAIN 5" - 0" CLEARANCE FROM BUILDING, WHILE OBSERVING 3' - 0" CLEARANCE ON ALL SIDES OF GENERATOR.


FLOW TEST INFORMATION
FLOW: TAKEN AT HYDRANT #326 AT 2803 DELMAR DR.
PRESSURE: TAKEN AT HYDRANT #325 AT 2785 DELMAR DR.
TEST DATE: 7/07
STATIC PRESSURE = 70 PSI
RESIDUAL PRESSURE = 40 PSI
FLOW = 900 GPM

SITE UTILITIES THAT ARE TO BE REMOVED SHALL BE REMOVED BY OTHERS.

2 WORKING DAYS
CALL BEFORE YOU DIG
CALL TOLL FREE 800-362-2764
OHIO UTILITIES PROTECTION SERVICE

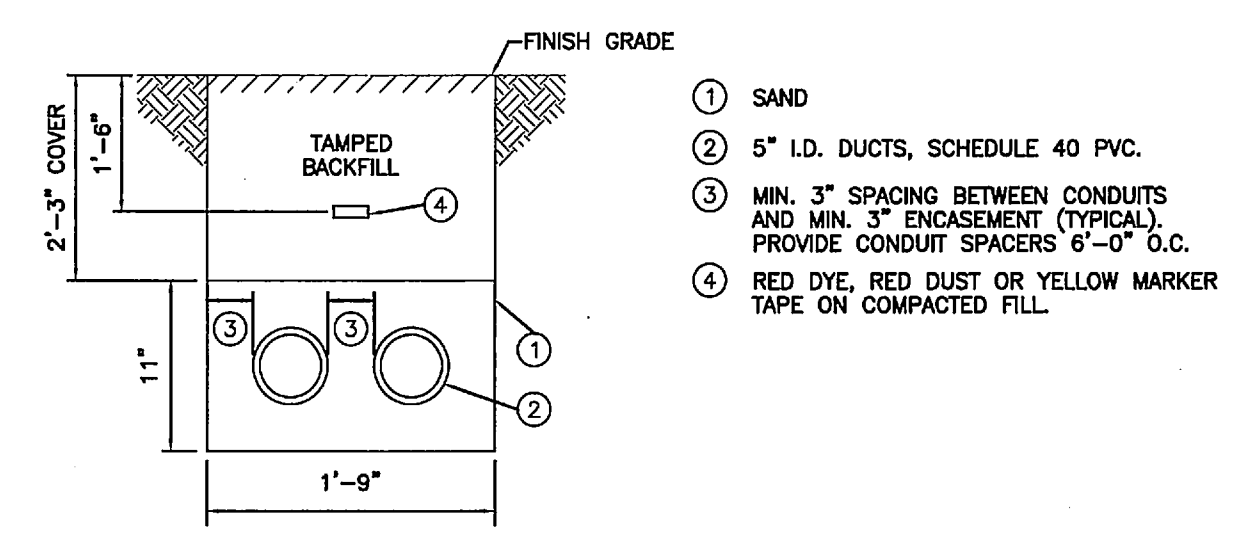

UNDERGROUND DUCTS
SCALE: NONE
A U100

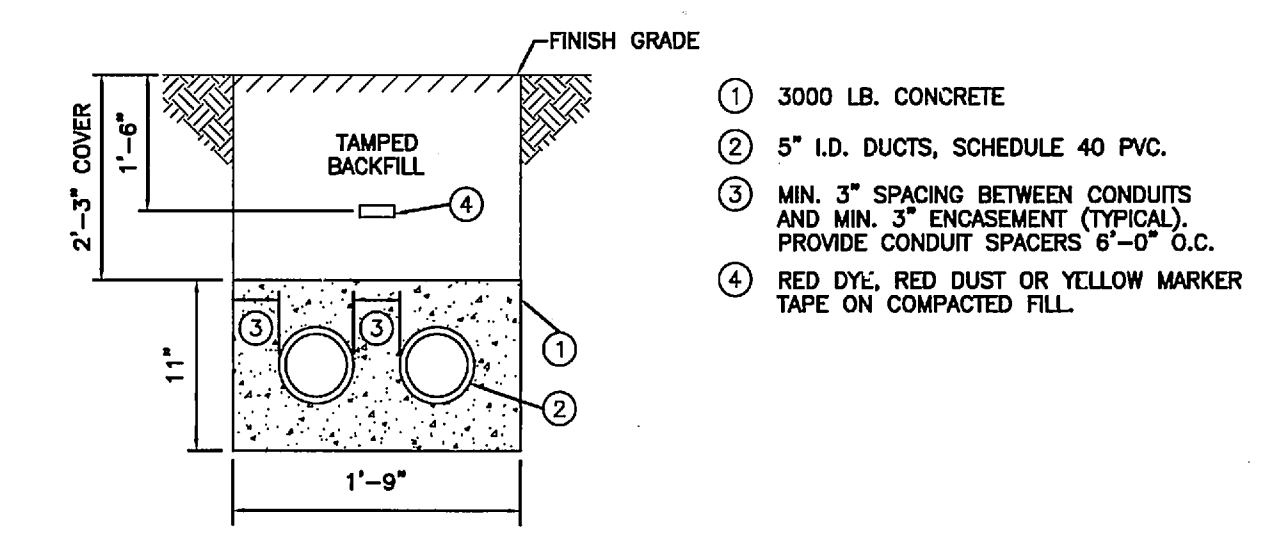

UNDERGROUND DUCTS
SCALE: NONE
B U100

PROJECT NO.: 2008-22012
PLOTTER: KLMcCoughney
DATE: August 4, 2008
DRAWN BY: KLMcCoughney
CHECKED BY: KLMcCoughney
MECHANICAL ELECTRICAL COMMISSIONING TECHNOLOGY